


Mechanical Drawings:
Sample HVAC, Basement

Sample Only

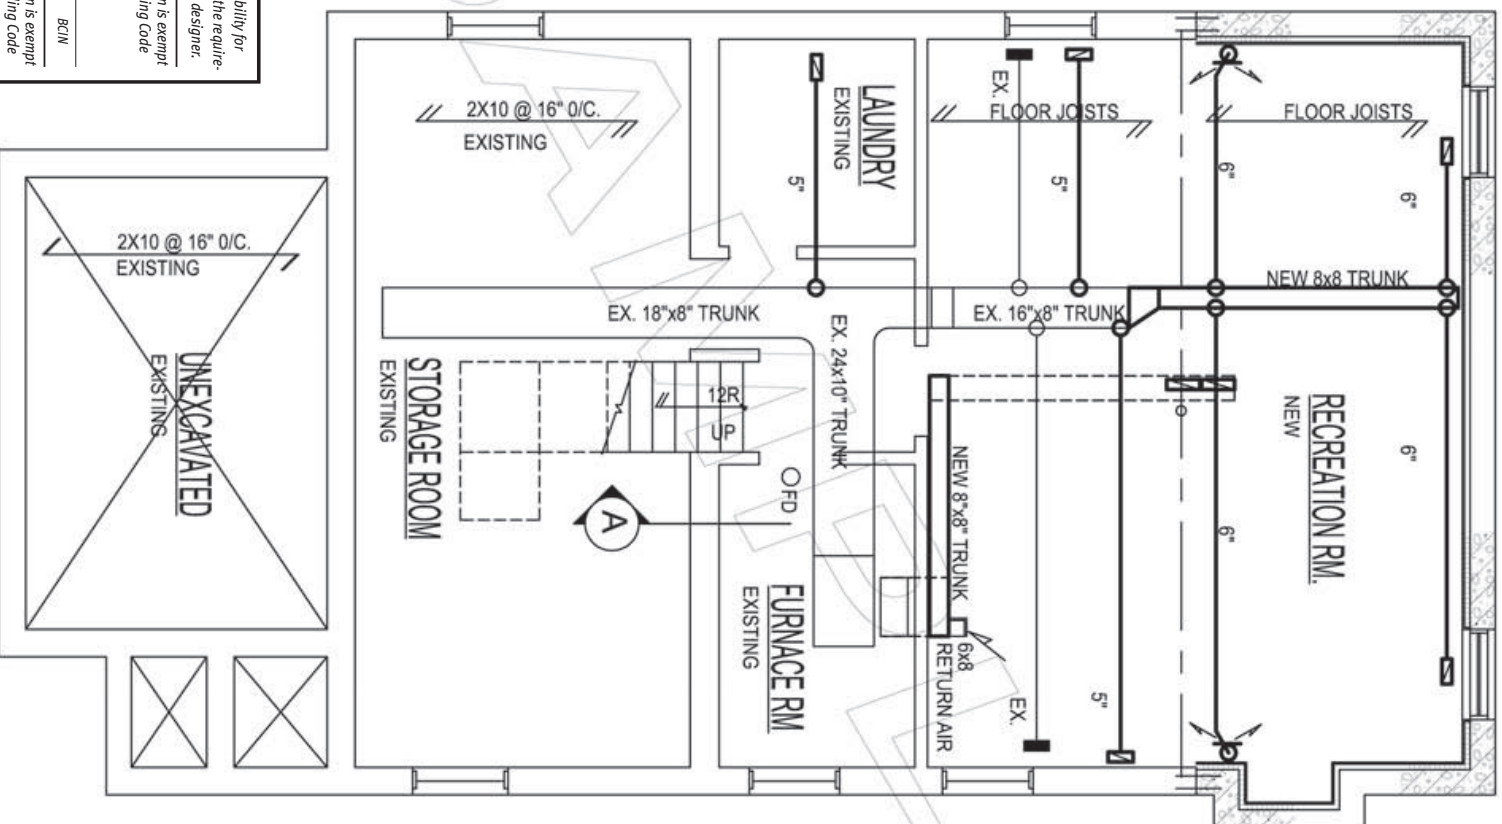

The undersigned has reviewed and takes responsibility for this design, and has the qualifications and meets the requirements set out in the Ontario Building Code to be a designer.

QUALIFICATION INFORMATION - Required unless design is exempt under 3.2.5.1 of Division "C" of the Ontario Building Code

NAME _____ SIGNATURE _____ BCIN _____

QUALIFICATION INFORMATION - Required unless design is exempt under 3.2.4.1 of Division "C" of the Ontario Building Code


FIRM NAME _____ BCIN _____

BASEMENT HVAC PLAN

SCALE 3/16" = 1'-0"

Mechanical Drawings:
Sample HVAC, First Floor

Sample Only

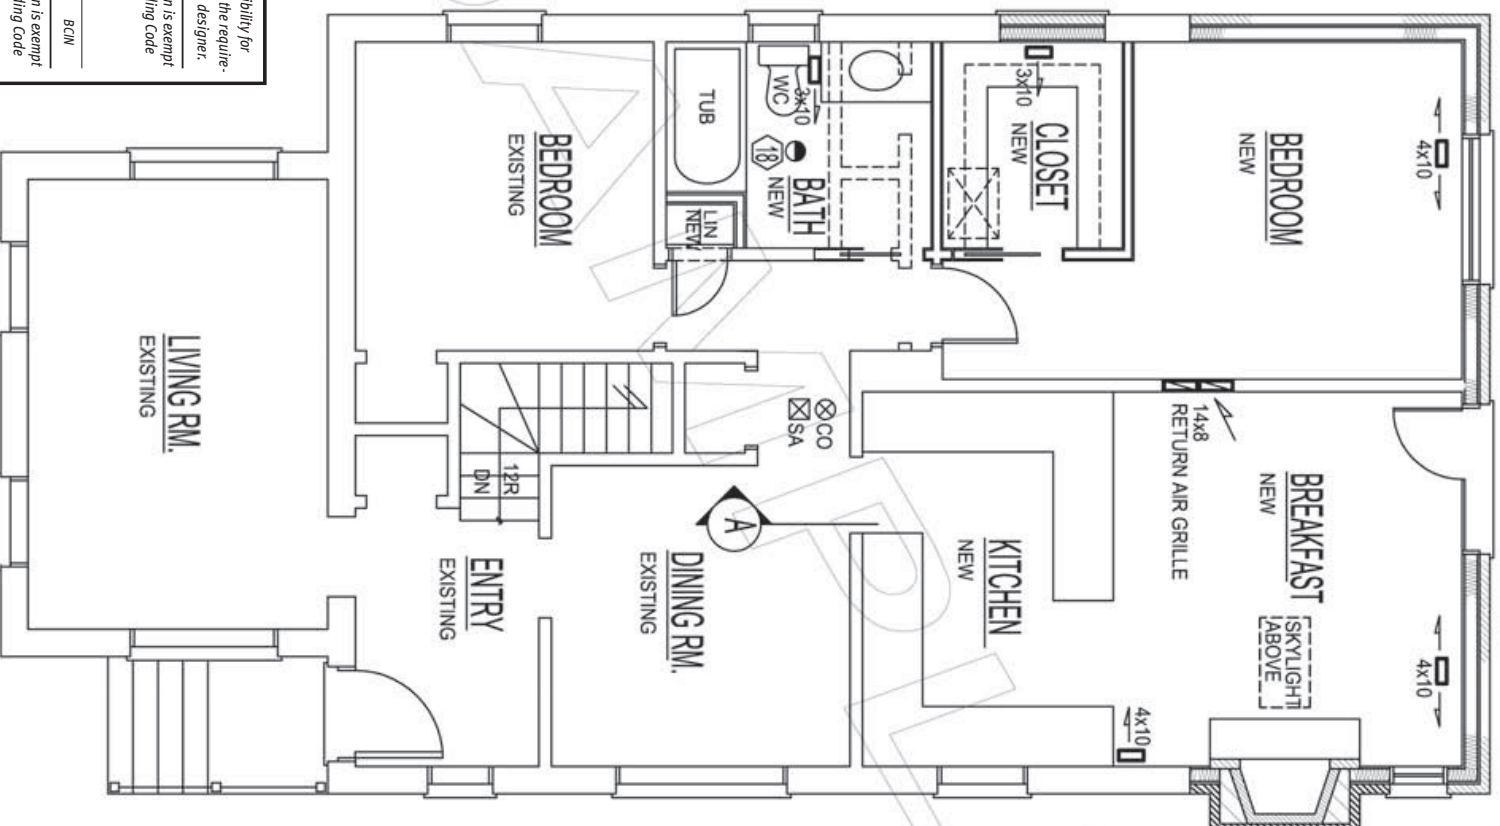

The undersigned has reviewed and takes responsibility for this design, and has the qualifications and meets the requirements set out in the Ontario Building Code to be a designer.

QUALIFICATION INFORMATION - Required unless design is exempt under 3.2.4.1 of Division "C" of the Ontario Building Code

under 3.2.5.1 of Division "C" of the Ontario Building Code

NAME	SIGNATURE	BCIN
FIRM NAME		BCIN

FIRST FLOOR HVAC PLAN
SCALE 3/16" = 1'-0"