


**SITE PLAN – PHOTOMETRIC**  
SCALE: 1:250

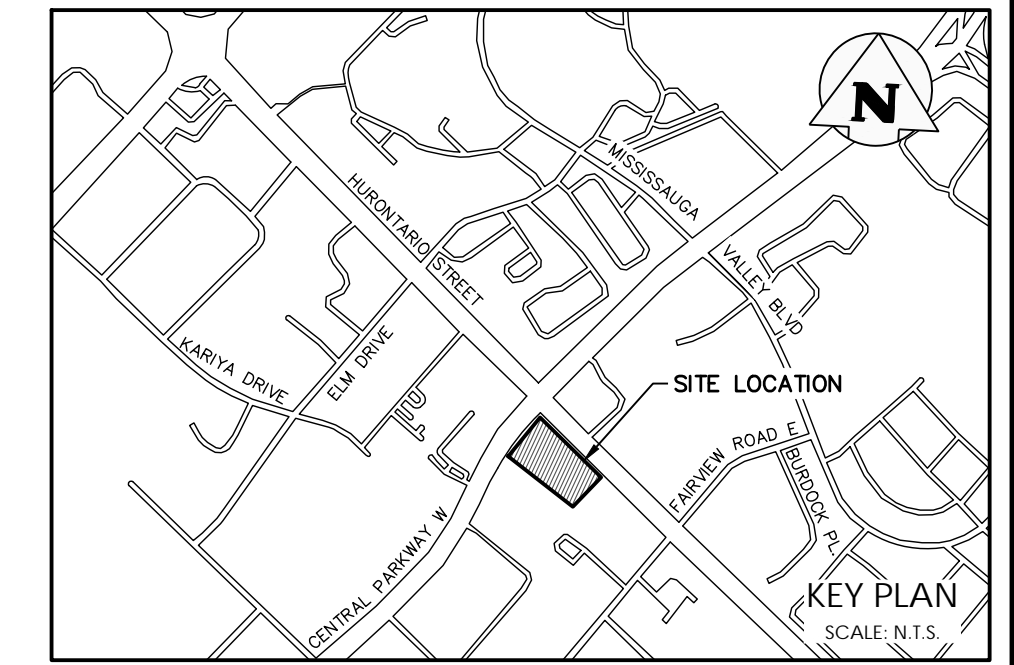

ELECTRICAL LEGEND	
LIGHTING	
	WALL MOUNTED LIGHT FIXTURE
	CEILING MOUNTED LIGHT FIXTURE
ABBREVIATIONS	
MH	MOUNTING HEIGHT
LINETYPES	
	PROPERTY LINE

ELECTRICAL DRAWING LIST	
E100	SITE PLAN – PHOTOMETRIC (DRAFT)
E101	LIGHTING DETAILS AND SCHEDULES

No.	ISSUE / REVISION	DATE:
0	ISSUED FOR FIRST SUBMISSION	11/20/20

North

Engineer

Engineer

**PRELIMINARY**  
NOT TO BE USED FOR CONSTRUCTION

- THIS DRAWING IS THE EXCLUSIVE PROPERTY OF C.F. CROZIER & ASSOCIATES INC. AND THE REPRODUCTION OF ANY PART WITHOUT PRIOR WRITTEN CONSENT OF THIS OFFICE IS STRICTLY PROHIBITED.
- THE CONTRACTOR SHALL VERIFY ALL DIMENSIONS, LEVELS, AND DATUMS ON SITE AND REPORT ANY DISCREPANCIES OR OMISSIONS TO THIS OFFICE PRIOR TO CONSTRUCTION.
- THIS DRAWING IS TO BE READ AND UNDERSTOOD IN CONJUNCTION WITH ALL OTHER PLANS AND DOCUMENTS APPLICABLE TO THIS PROJECT.
- DO NOT SCALE THE DRAWINGS.
- ALL EXISTING UNDERGROUND UTILITIES TO BE VERIFIED IN THE FIELD BY THE CONTRACTOR PRIOR TO CONSTRUCTION.

Project

**3420 HURONTARIO STREET  
CITY OF MISSISSAUGA**

Drawing

**SITE PLAN – PHOTOMETRIC (DRAFT)**

**CROZIER**  
CONSULTING ENGINEERS

2800 High Point Drive  
Suite 100  
Mississauga, ON L9T 6P4  
905-875-0026 T  
905-875-4915 F  
www.cfcrozier.ca

Drawn By	E.L.	Design By	R.T./I.S.	Project	1932-5666
Scale	1:250	Check By	M.S.	Drawing	E100