
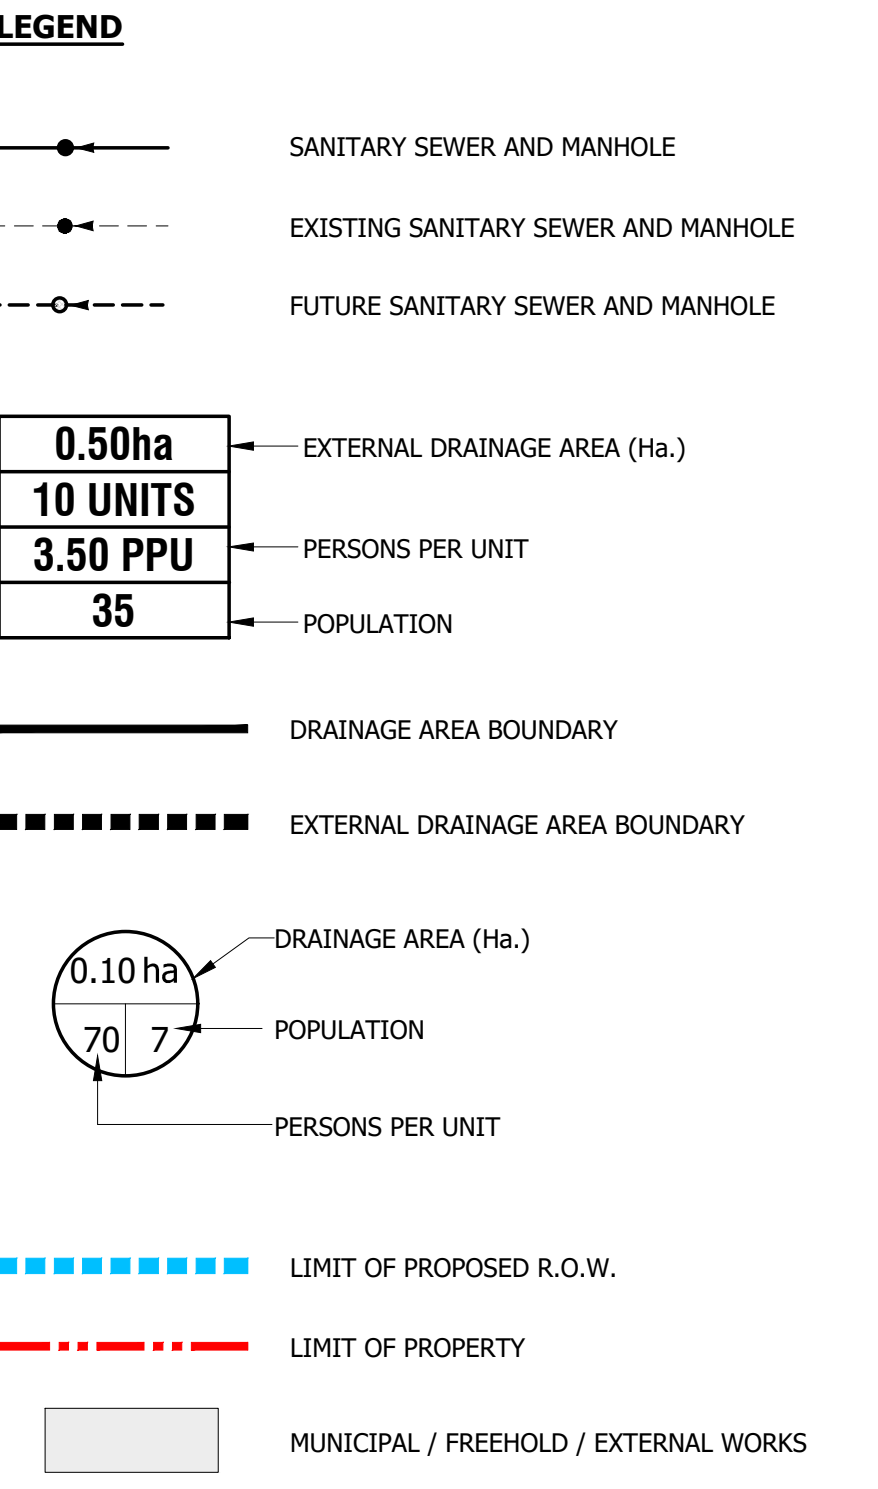
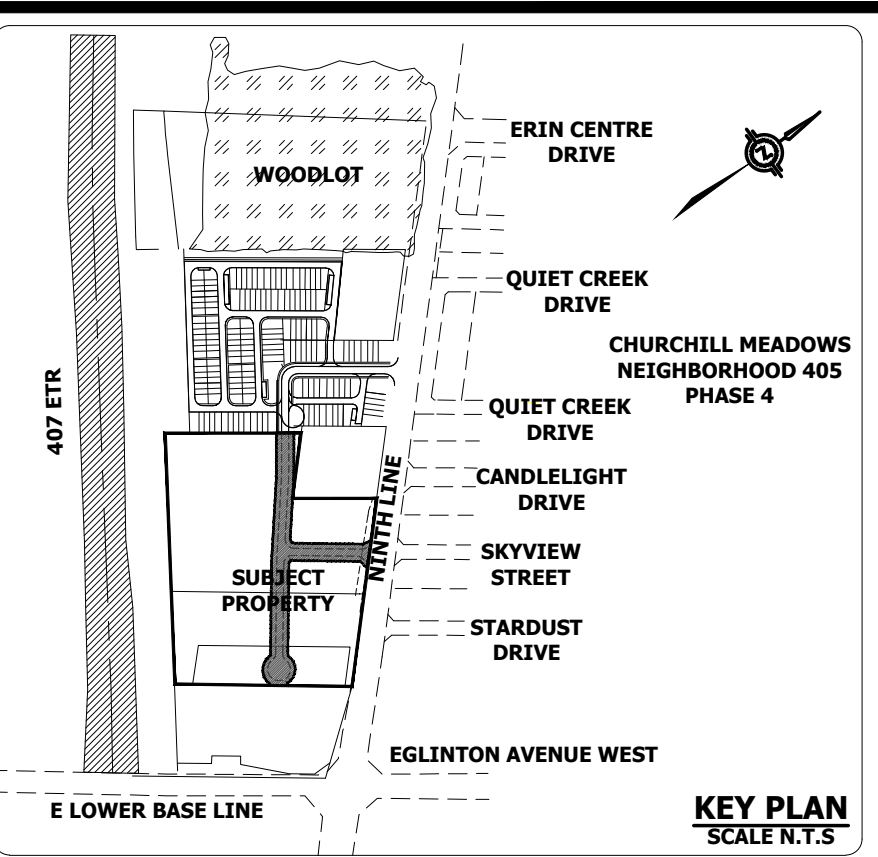


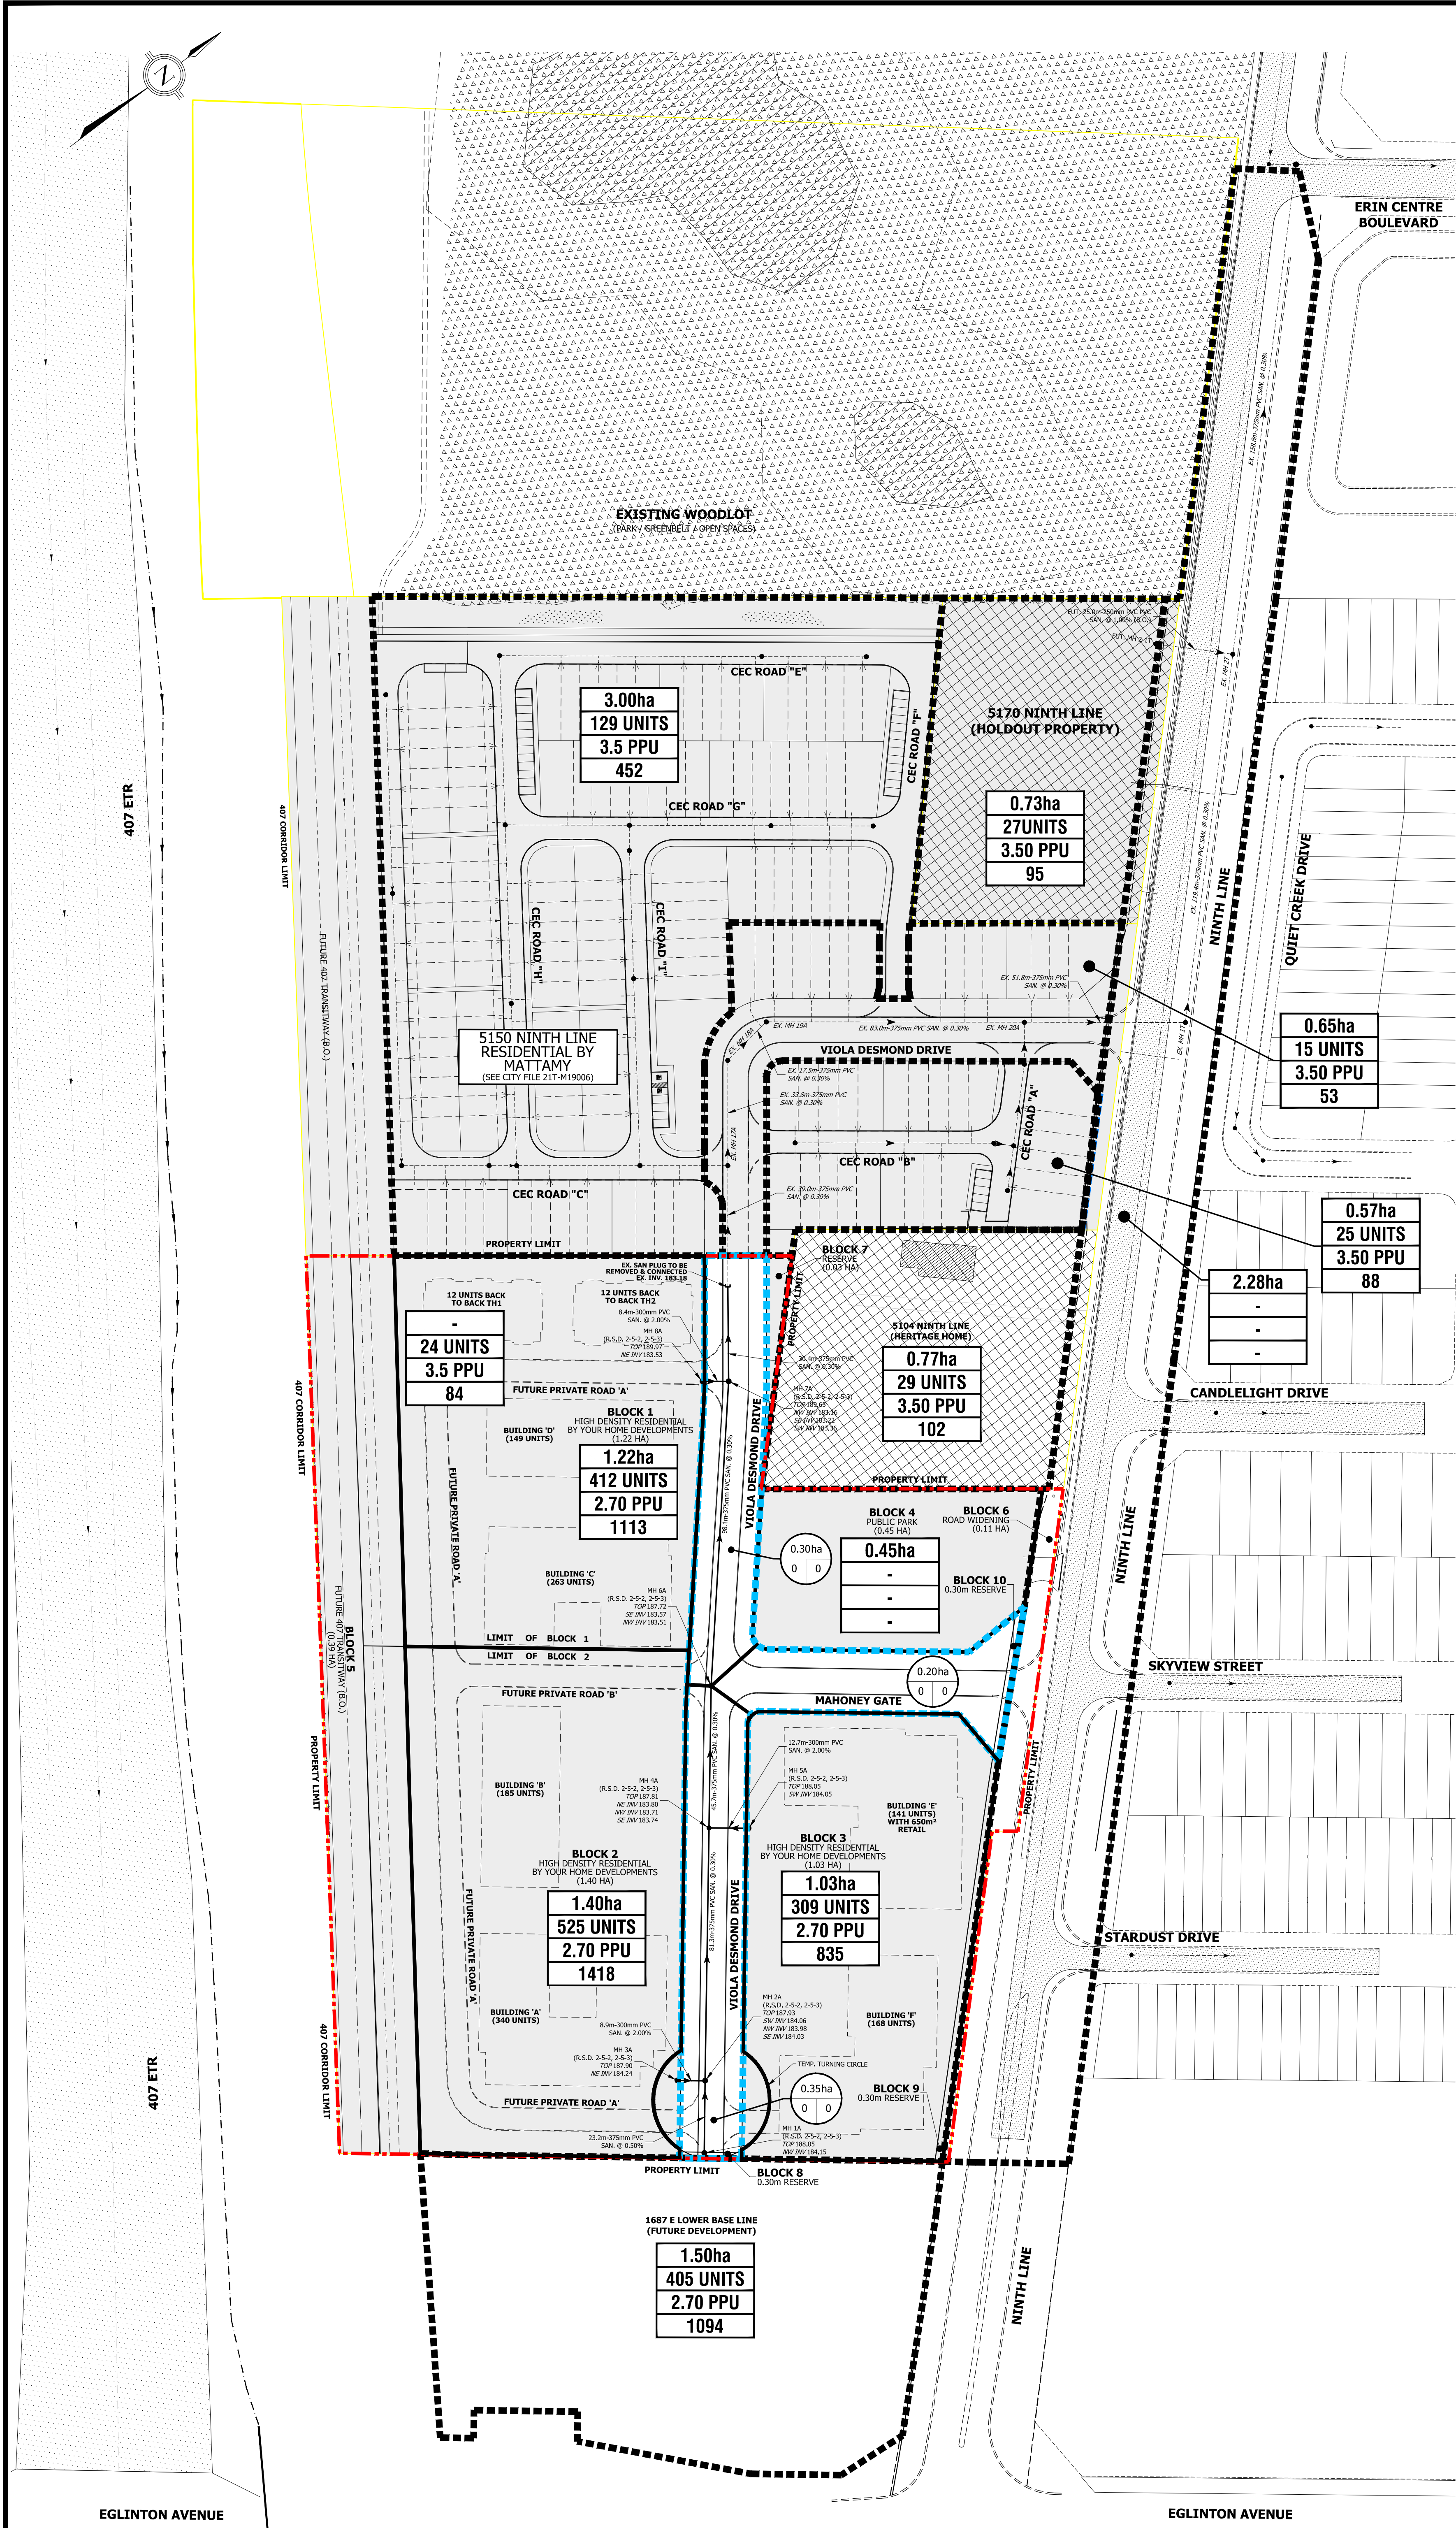

LOCAL BENCHMARK:
LOCAL BENCHMARK NO. 075033001 BRASS CAP IN CONCRETE CYLINDER, 9 METRES ON THE EAST SIDE OF THE CENTRELINE OF NINTH LINE, 14 METRES NORTH OF THE CENTRELINE OF ROADSIDE WAY. ELEVATION = 193.804 METRES

4			
3			
2			
1			

No.	REVISION	DATE	BY
-----	----------	------	----

Urbantech® Consulting
A Division of Leighton-Zec Ltd.
3760 14th Avenue, Suite 301,
Markham, ON, L3R 3T7
TEL 905 946 9461 • urbantech.com

5080 NINTH LINE

YOUR HOME DEVELOPMENTS
4965 STEELES AVE W
NORTH YORK, ON, M9L 1R4
416-745-6686

Region
of Peel
Working for you

MISSISSAUGA

SANITARY DRAINAGE PLAN

PROJECT #:	19-607	DRAWING:	
SITE PLAN FILE No.:	#####		
SUBDIVISION FILE No.:	#####		
CITY FILE No.:	#####		
REGION FILE No.:	#####		
DESIGNED:	B.J.	CHECKED:	B.J.
DRAWN:	J.M.	DATE:	SEPT. 2021
SCALE:	1:1000		