


DEPARTMENTS

- 21 INFORMATION SERVICES
- 32 CORPORATE SERVICES
- CIRCULATION PAT/STAFF
- ELEVATOR LABOUR/ DELIVERY
- ELEVATOR LABOUR/ DELIVERY - OVERRUN
- ELEVATOR PAT/STAFF
- ELEVATOR PUBLIC
- ELEVATOR SERVICE - AGV
- ELEVATOR SERVICE - MDR
- ELEVATOR SERVICE - MDR - OVERRUN
- ELEVATOR SERVICE - OVERRUN
- ELEVATOR SERVICE/STAFF
- ELEVATOR TRAUMA
- PLANT - ELEC
- PLANT - MECH
- STAIRS

1 DEPARTMENTAL ZONE STUDY - LEVEL 7 M&E PLANT
A-204 1:500

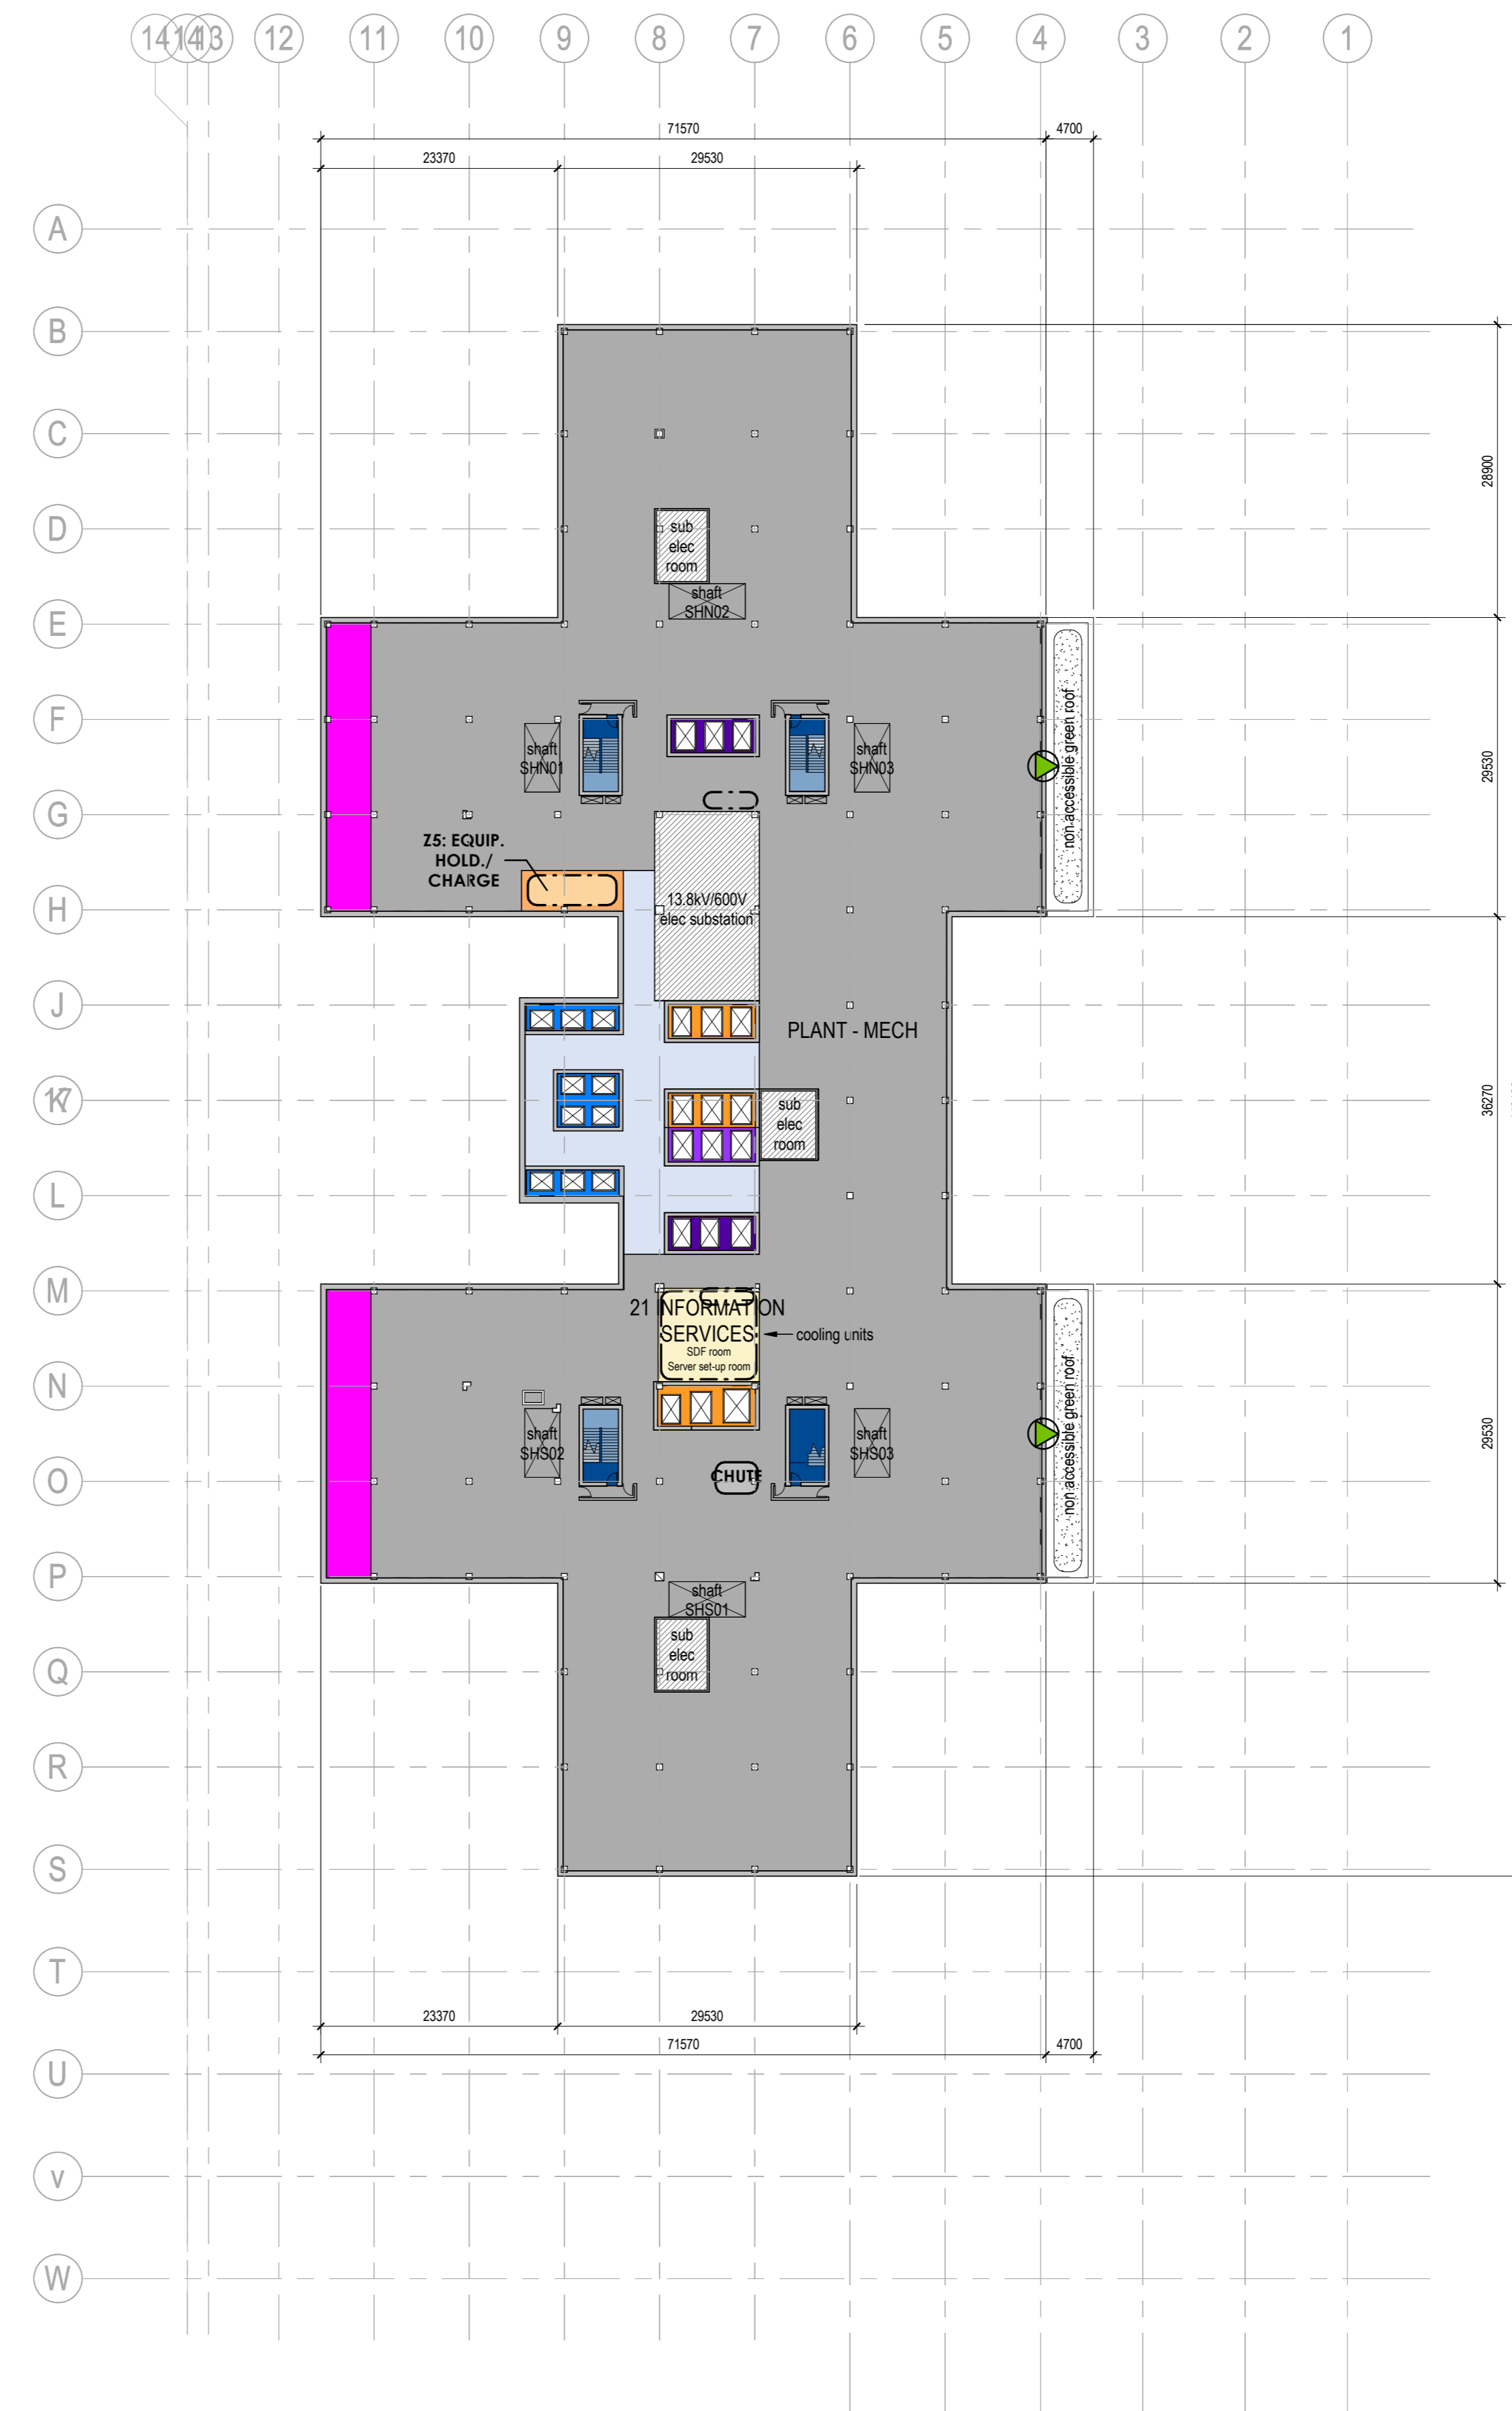

DEPARTMENTS

- 21 INFORMATION SERVICES
- 32 CORPORATE SERVICES
- CIRCULATION PAT/STAFF
- ELEVATOR PAT/STAFF
- ELEVATOR PUBLIC
- ELEVATOR SERVICE - AGV
- ELEVATOR SERVICE/STAFF
- PLANT - ELEC
- PLANT - MECH
- STAIRS
- UNASSIGNED

2 DEPARTMENTAL ZONE STUDY - LEVEL 15 M&E PLANT
A-204 1:500

DEPARTMENTAL ZONE LEGEND

- ACCESSIBLE TERRACE TYPE**
*INDICATES BALCONIES
- PROGRAMMED ROOF TERRACE (APPROX. 80% PAVING / 20% PLANTING)
 - PROPOSED HARD LANDSCAPING
 - PAVING AT GRADE ABOVE OCCUPIED BELOW-GRADE BUILDING AREA
- ROOF TYPE**
- TYPE 1 - NON ACCESSIBLE VEGETATIVE ROOF (APPROX. 80% PLANTING / 20% GRAVEL SERVICE PATHS)
 - TYPE 2 - NON ACCESSIBLE DECORATIVE GRAVEL ROOF
 - TYPE 3 - TYPICAL FLAT ROOF
 - TYPE 4 - HIGH SRI FLAT ROOF
- OTHER SYMBOLS**
- ENTRANCE - PUBLIC
 - ENTRANCE - PATIENT/STAFF
 - ENTRANCE - SERVICE
 - EMERGENCY EXIT
 - TERRACE/ROOFTOP ACCESS
 - FLOW LINE - PUBLIC
 - FLOW LINE - PATIENT/STAFF
 - FLOW LINE - SERVICE
 - FLOW LINE - TRAUMA
 - 90 MIN FIRE SEPERATION (REFER TO I/O)

| Issue/Revision | By | App'd | DATE |
|----------------|----|-------|------------|
| 5 | | | 2021.12.06 |
| 4 | | | 2021.08.06 |
| 3 | | | 2021.05.11 |
| 2 | | | 2021.03.04 |
| 1 | | | 2020.12.18 |

CONFIDENTIAL PROJECT
NOT FOR CONSTRUCTION

Client/Project Logo



Client/Project
TRILLIUM HEALTH PARTNERS
NEW MISSISSAUGA HOSPITAL TOWER
PAM 21-323 W7

100 QUEENSWAY WEST & 2250 HURONTARIO ST
MISSISSAUGA ON

Title
LEVEL 7 AND 15 MECHANICAL PLANT PLANS

Project No. 1400200191 Scale As Indicated
Revision Drawing No. **A-204**

