

ISSUED FOR

1	2021-04-21	PRE-APPLICATION MEETING (PAM)
2	2021-05-20	SCHEMATIC DESIGN
3	2021-06-25	QA 50%
4	2021-07-23	100% DESIGN DEVELOPMENT QA
5	2021-08-06	BID BP01
6	2021-08-06	BUILDING PERMIT
7	2021-08-06	SITE PLAN APPROVAL

METRIC
 THIS DRAWING IS COPYRIGHTED AND MUST NOT BE USED, REPRODUCED, OR REVISED WITHOUT WRITTEN PERMISSION. VERIFY DIMENSIONS. DO NOT SCALE THIS DRAWING.

REPORT INCONSISTENCIES AND OMISSIONS TO THE CONSULTANT FOR CLARIFICATION BEFORE COMMENCING WITH THE WORK. DEVIATIONS FROM THE CONTRACT DOCUMENTS WITHOUT WRITTEN APPROVAL FROM THE CONSULTANT ARE SUBJECT TO CORRECTION AT THE CONTRACTOR'S EXPENSE.

CLIENT
 TRILLIUM HEALTH PARTNERS
 150 DERRWAY DR. ETOBICOKE
 TORONTO, ON M9C 1A5
 TEL: (416) 291-8871 WEBSITE: trilliumhealthpartners.ca

CONSTRUCTION MANAGER
 KENADAN CONTRACTING LTD.
 7801 BERRYPREST DRIVE
 MISSISSAUGA, ON L5N 0G5
 TEL: (905) 910-2680 WEBSITE: www.kenadan.com/

ARCHITECT & PRIME CONSULTANT
 DIALOG
 35 JOHN STREET, SUITE 500
 TORONTO, ON M5V 2S8
 TEL: (416) 966-0220 WEBSITE: dialogdesign.ca

STRUCTURAL ENGINEER
 DIALOG

MECHANICAL ENGINEER
 DIALOG

ELECTRICAL ENGINEER
 DIALOG

LANDSCAPE ARCHITECT
 DIALOG

CIVIL ENGINEER
 MTE CONSULTANTS INC.
 1018 SUTTON DRIVE, UNIT A
 BURLINGTON, ON L7R 1B8
 TEL: (905) 639-2322 WEBSITE: mte85.com

SECURITY
 THE ATARM GROUP INC.
 298-180 WOODWARD DRIVE
 OTTAWA, ON K2E 2P7
 TEL: (613) 817-5999 WEBSITE: theatarmgroup.com

SIGNAGE AND WAYFINDING
 ENTRIO
 33 HARBOUR SQUARE, SUITE 202
 TORONTO, ON M5J 2G2
 TEL: (416) 368-8888 WEBSITE: entrio.com

VIBRATION, NOISE, ACOUSTICS
 SWALLOW ACOUSTICS CONSULTANTS LTD.
 23360 REVELS AVENUE
 MISSISSAUGA, ON L5G 4S5
 TEL: (905) 271-7859 WEBSITE: torontotonasouth.com

BUILDING CODE
 LRI ENGINEERING INC.
 171 UNIVERSITY AVE. 3RD FLOOR, BOX 1
 TORONTO, ON M5H 1B3
 TEL: (416) 515-9331 WEBSITE: lrinfo.com

VERTICAL TRANSPORTATION
 SOBEMAN ENGINEERING INC.
 95 ST. CLAIR AVENUE WEST, SUITE 205
 TORONTO, ON M5V 1Y7
 TEL: (416) 323-2133 WEBSITE: sobemanengineering.com

HARDWARE
 SPYDER SC
 35 HILDA RD
 WOODBRIDGE, ON L4H 3M5
 TEL: (847) 271-6459 WEBSITE: spydersc.com

KEYPLAN

MISSISSAUGA HOSPITAL
 100 QUEENSWAY WEST
 MISSISSAUGA, ONTARIO
 L5B 1B8

SITE PLAN NEW CONSTRUCTION - PART 1

DRAWN: Author CHECKED: Checker
 PLOT DATE: 8/13/2021 12:17:46 PM

A121

SCALE: 1:200

PROJECT NORTH

THP M-SITE HOSPITAL PARKING STRUCTURE


500x500 UNDERGROUND ELECTRICAL BUS DUCT

SITE PLAN NEW CONSTRUCTION - PART 1

SCALE: 1:200

A121

SCALE: 1:200

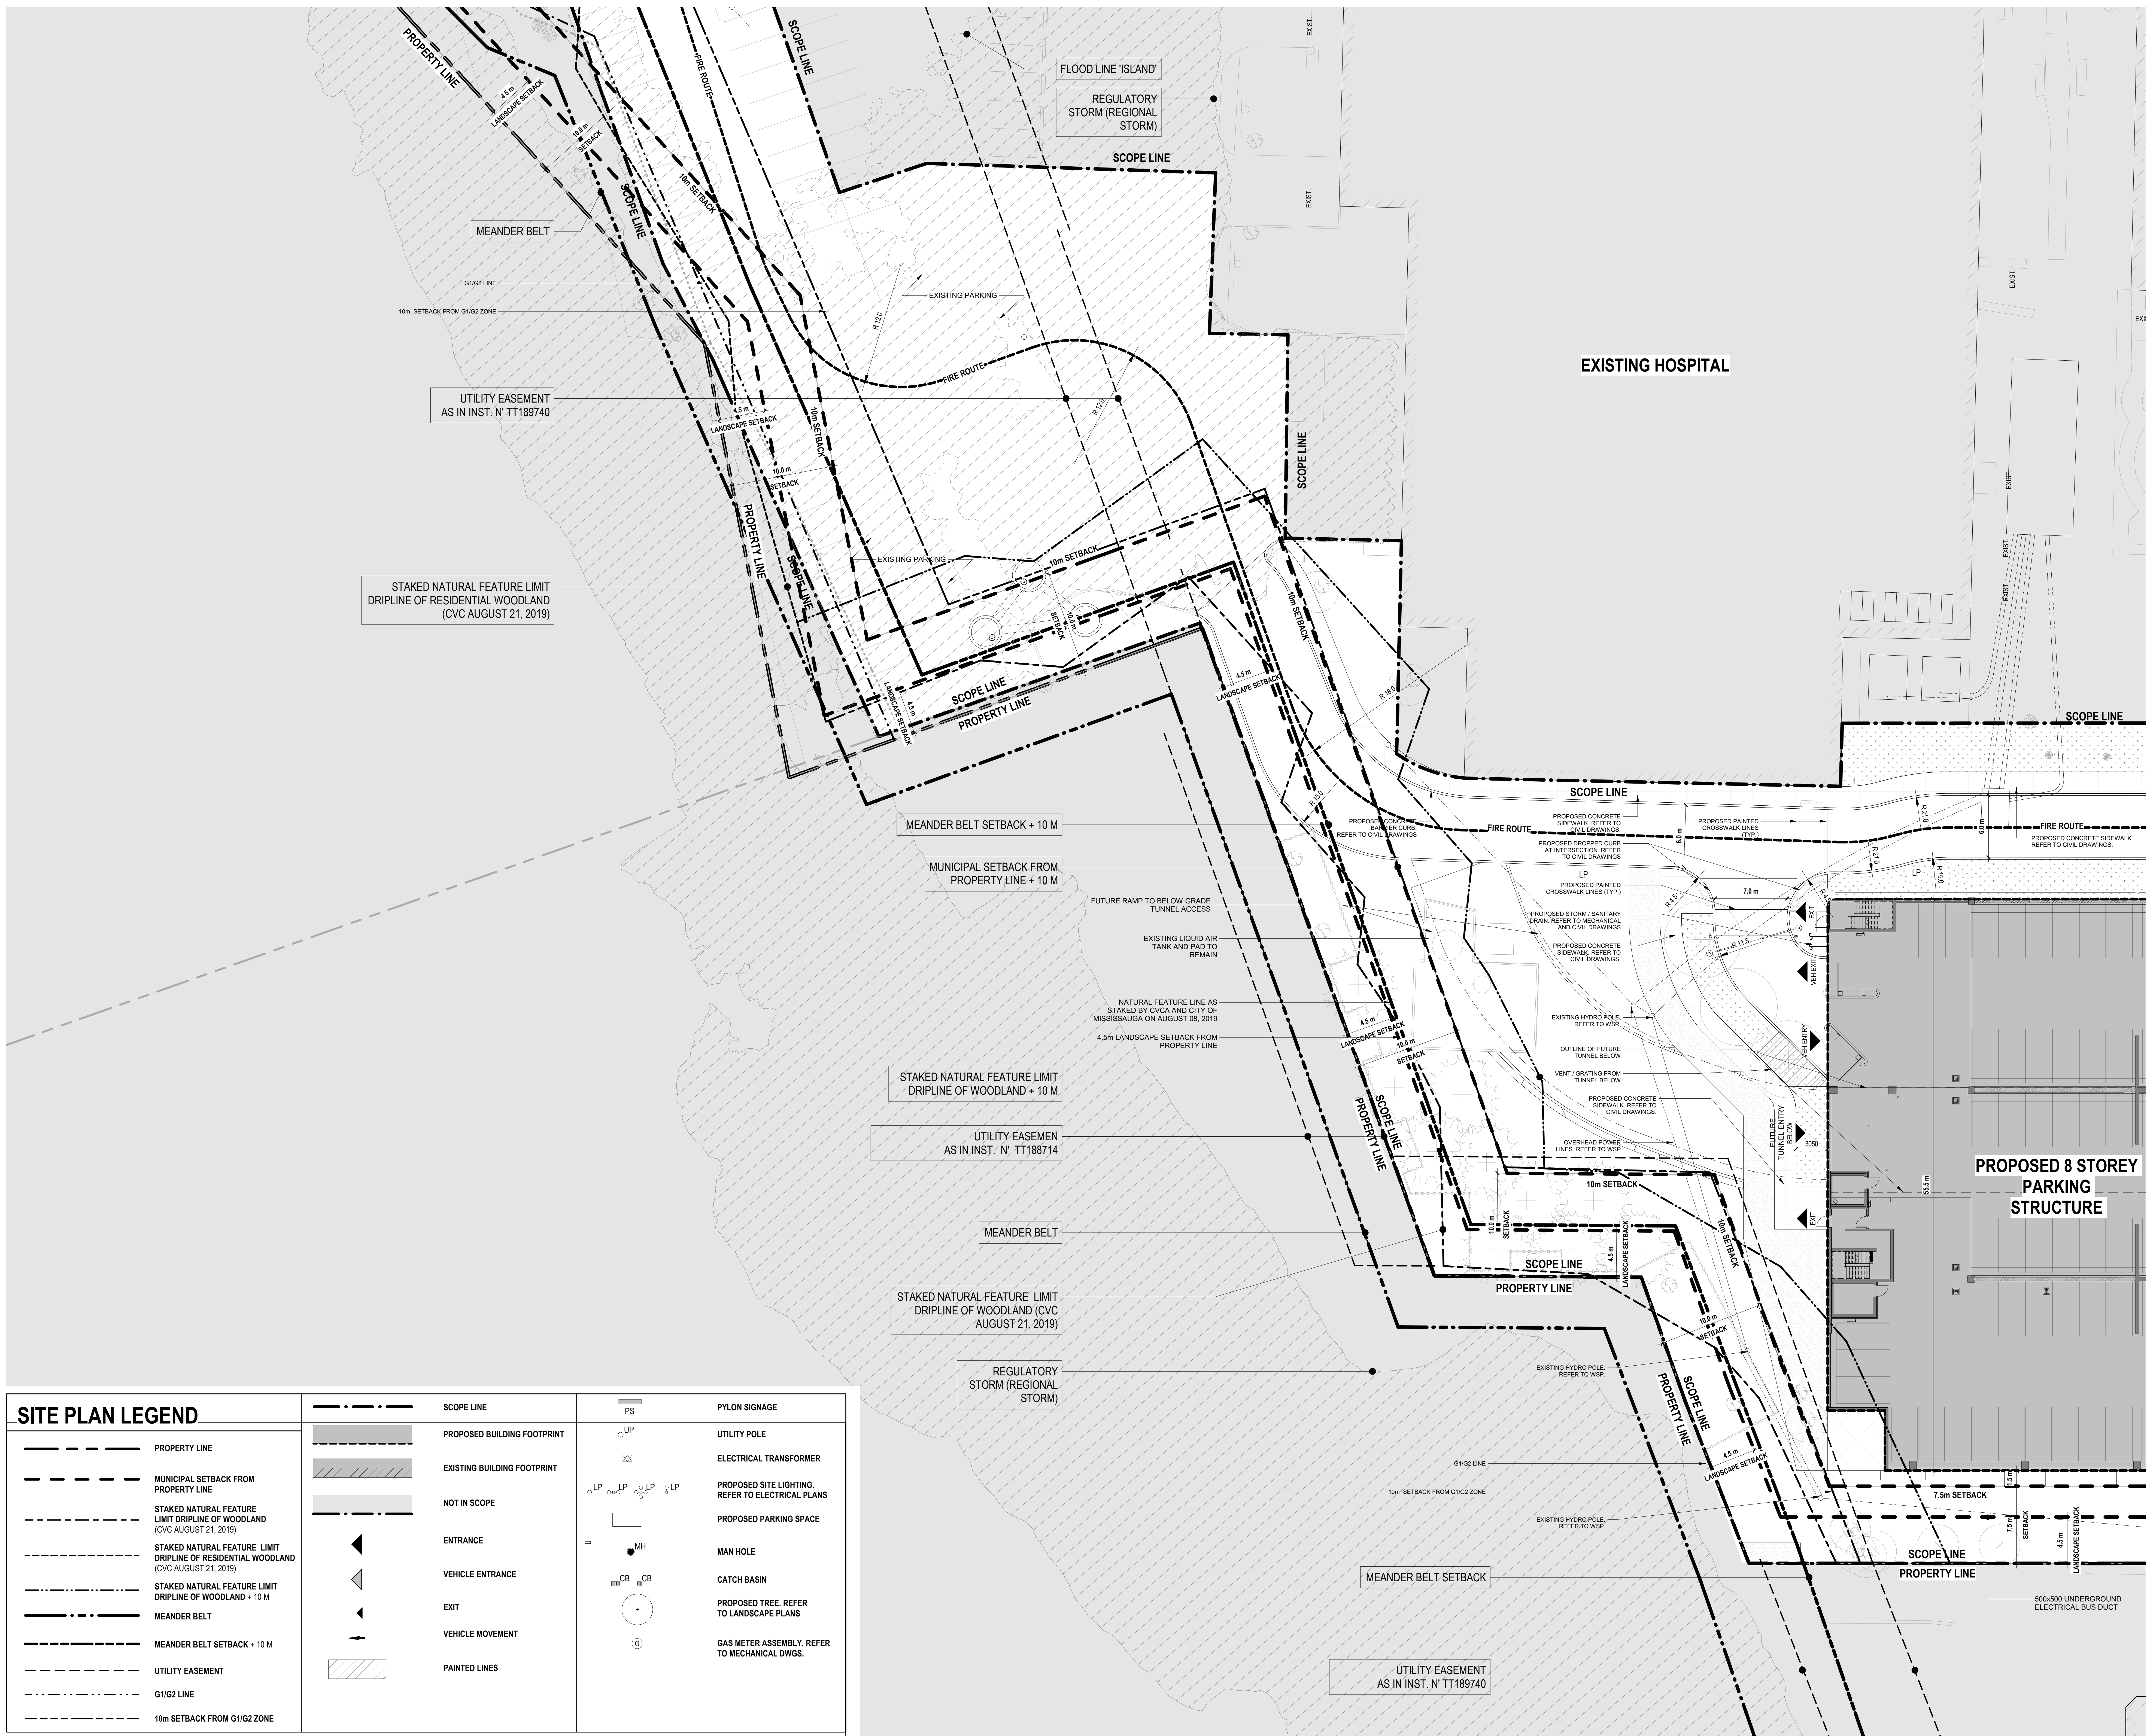

SITE PLAN LEGEND		SYMBOLS	
--- PROPERTY LINE	--- SCOPE LINE	PS	PYLON SIGNAGE
--- MUNICIPAL SETBACK FROM PROPERTY LINE	--- PROPOSED BUILDING FOOTPRINT	UP	UTILITY POLE
--- STAKED NATURAL FEATURE LIMIT DRIPLINE OF WOODLAND (CVC AUGUST 21, 2019)	--- EXISTING BUILDING FOOTPRINT	ET	ELECTRICAL TRANSFORMER
--- STAKED NATURAL FEATURE LIMIT DRIPLINE OF RESIDENTIAL WOODLAND (CVC AUGUST 21, 2019)	--- NOT IN SCOPE	LP	PROPOSED SITE LIGHTING. REFER TO ELECTRICAL PLANS
--- STAKED NATURAL FEATURE LIMIT DRIPLINE OF WOODLAND + 10 M	--- ENTRANCE	MH	PROPOSED PARKING SPACE
--- STAKED NATURAL FEATURE LIMIT DRIPLINE OF WOODLAND + 10 M	--- VEHICLE ENTRANCE	CB	MAN HOLE
--- MEANDER BELT	--- EXIT	CB	CATCH BASIN
--- MEANDER BELT SETBACK + 10 M	--- VEHICLE MOVEMENT	GA	PROPOSED TREE. REFER TO LANDSCAPE PLANS
--- UTILITY EASEMENT	--- PAINTED LINES	GA	GAS METER ASSEMBLY. REFER TO MECHANICAL DWGS.
--- G1/G2 LINE			
--- 10m SETBACK FROM G1/G2 ZONE			

