

SITE PLAN LEGEND	
	PROPERTY LINE
	MUNICIPAL SETBACK FROM PROPERTY LINE
	STAKED NATURAL FEATURE LIMIT DRIPLINE OF WOODLAND (CVC AUGUST 21, 2019)
	STAKED NATURAL FEATURE LIMIT DRIPLINE OF RESIDENTIAL WOODLAND (CVC AUGUST 21, 2019)
	STAKED NATURAL FEATURE LIMIT DRIPLINE OF WOODLAND + 10 M
	MEANDER BELT
	MEANDER BELT SETBACK + 10 M
	UTILITY EASEMENT
	G1/G2 LINE
	10m SETBACK FROM G1/G2 ZONE
	PROPOSED BUILDING FOOTPRINT
	EXISTING BUILDING FOOTPRINT
	NOT IN SCOPE
	ENTRANCE
	VEHICLE ENTRANCE
	EXIT
	VEHICLE MOVEMENT
	PAINTED LINES
	PYLON SIGNAGE
	UTILITY POLE
	ELECTRICAL TRANSFORMER
	PROPOSED SITE LIGHTING, REFER TO ELECTRICAL PLANS
	PROPOSED PARKING SPACE
	MAN HOLE
	CATCH BASIN
	PROPOSED TREE, REFER TO LANDSCAPE PLANS
	GAS METER ASSEMBLY, REFER TO MECHANICAL DWGS.





ISSUED FOR	
1	2021-05-20 SCHEMATIC DESIGN
2	2021-06-25 QA 50%
3	2021-07-23 100% DESIGN DEVELOPMENT QA
4	2021-08-05 BID BP01
5	2021-08-06 BUILDING PERMIT
6	2021-08-06 SITE PLAN APPROVAL

METRIC
 THIS DRAWING IS COPYRIGHTED AND MUST NOT BE USED, REPRODUCED, OR REVISED WITHOUT WRITTEN PERMISSION. ALL DIMENSIONS ARE IN MILLIMETERS UNLESS OTHERWISE NOTED. VERIFY DIMENSIONS. DO NOT SCALE THIS DRAWING.

REPORT INCONSISTENCIES AND OMISSIONS TO THE CONSULTANT FOR CLARIFICATION BEFORE COMMENCING WITH THE WORK. DEVIATIONS FROM THE CONTRACT DOCUMENTS WITHOUT WRITTEN APPROVAL FROM THE CONSULTANT ARE SUBJECT TO CORRECTION AT THE CONTRACTOR'S EXPENSE.

- CLIENT**
 TRILLIUM HEALTH PARTNERS
 150 DUNDAS ST. W. TORONTO, ONT. M5G 1A5
 TEL: (416) 595-8571 WEBSITE: trilliumhealthpartners.ca
- CONSTRUCTION MANAGER**
 KENADIAN CONTRACTING LTD.
 780 BERRYPURCH DRIVE, MISSISSAUGA, ON L5N 0G5
 TEL: (905) 910-2680 WEBSITE: www.kenadan.com/
- ARCHITECT & PRIME CONSULTANT**
 DIALOG
 35 JOHN STREET, SUITE 500 TORONTO, ON M5V 3G8
 TEL: (416) 966-0220 WEBSITE: dialogdesign.ca
- STRUCTURAL ENGINEER**
 DIALOG
- MECHANICAL ENGINEER**
 DIALOG
- ELECTRICAL ENGINEER**
 DIALOG
- LANDSCAPE ARCHITECT**
 DIALOG
- CIVIL ENGINEER**
 MTE CONSULTANTS INC.
 1018 SUTTON DRIVE, UNIT A BURLINGTON, ON L7R 1B8
 TEL: (905) 639-2322 WEBSITE: mte85.com
- SECURITY**
 THE ATARIAN GROUP INC.
 285-180 WOODWARD DRIVE OTTAWA, ON K2C 3P7
 TEL: (613) 817-5999 WEBSITE: theatariangroup.com
- SIGNAGE AND WAYFINDING**
 ENTRIO
 33 HARBOUR SQUARE, SUITE 202 TORONTO, ON M5J 2G2
 TEL: (416) 368-8888 WEBSITE: entrio.com
- VIBRATION, NOISE, ACOUSTICS**
 SWALLOW ACOUSTICS CONSULTANTS LTD.
 23366 REVELS AVENUE, MISSISSAUGA, ON L5G 4S5
 TEL: (905) 271-7889 WEBSITE: thortontonsnaitli.com
- BUILDING CODE**
 LRI ENGINEERING INC.
 171 UNIVERSITY AVE., 3RD FLOOR, BOX 1 TORONTO, ON M5H 3B3
 TEL: (416) 515-9331 WEBSITE: lrifra.com
- VERTICAL TRANSPORTATION**
 SOBEMAN ENGINEERING INC.
 55 ST. CLAIR AVENUE WEST, SUITE 205 TORONTO, ON M4V 2T7
 TEL: (416) 323-2133 WEBSITE: sobemanengineering.com
- HARDWARE**
 SPYDER SC
 35 HILDA RD WOODBRIDGE, ON L4H 3M5
 TEL: (847) 271-6489 WEBSITE: spydersc.com

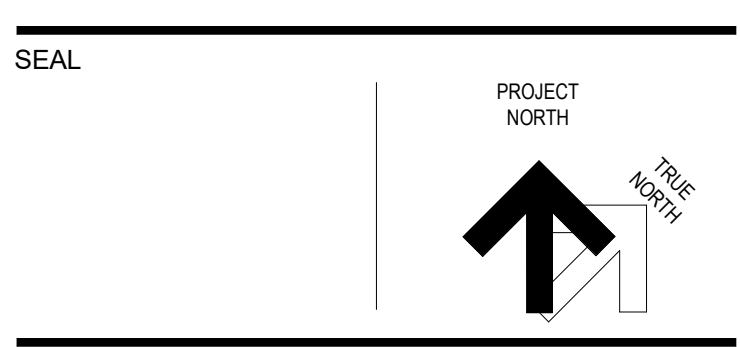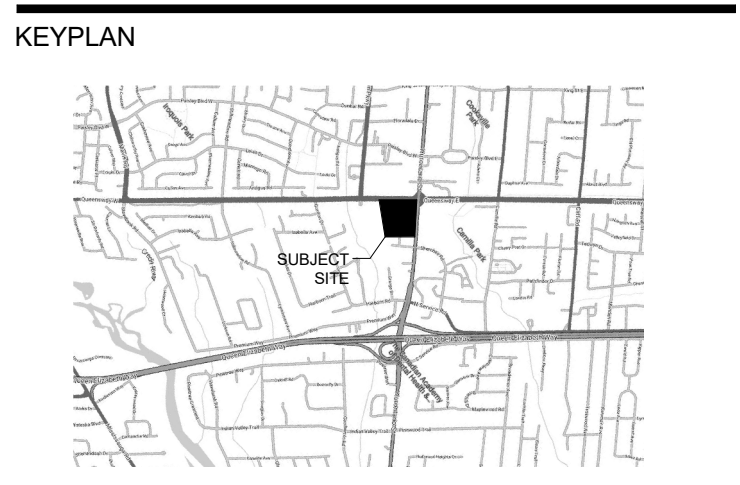


THP M-SITE HOSPITAL PARKING STRUCTURE

MISSISSAUGA HOSPITAL
 100 QUEENSWAY WEST
 MISSISSAUGA, ONTARIO
 L5B 1B8

SITE PLAN NEW CONSTRUCTION - PART 3

DRAWN: Author CHECKED: Checker
 PLOT DATE: 8/13/2021 12:17:56 PM

A123

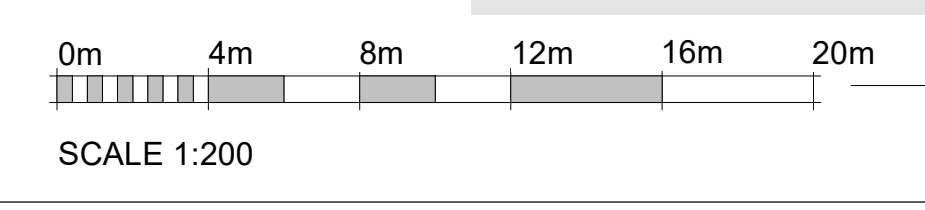

SITE PLAN NEW CONSTRUCTION - PART 3
 SCALE: 1:200

C:\Rev\Local Files\DLG_2005572_AR_THP_M_PARKING_rjgmm.rvt