



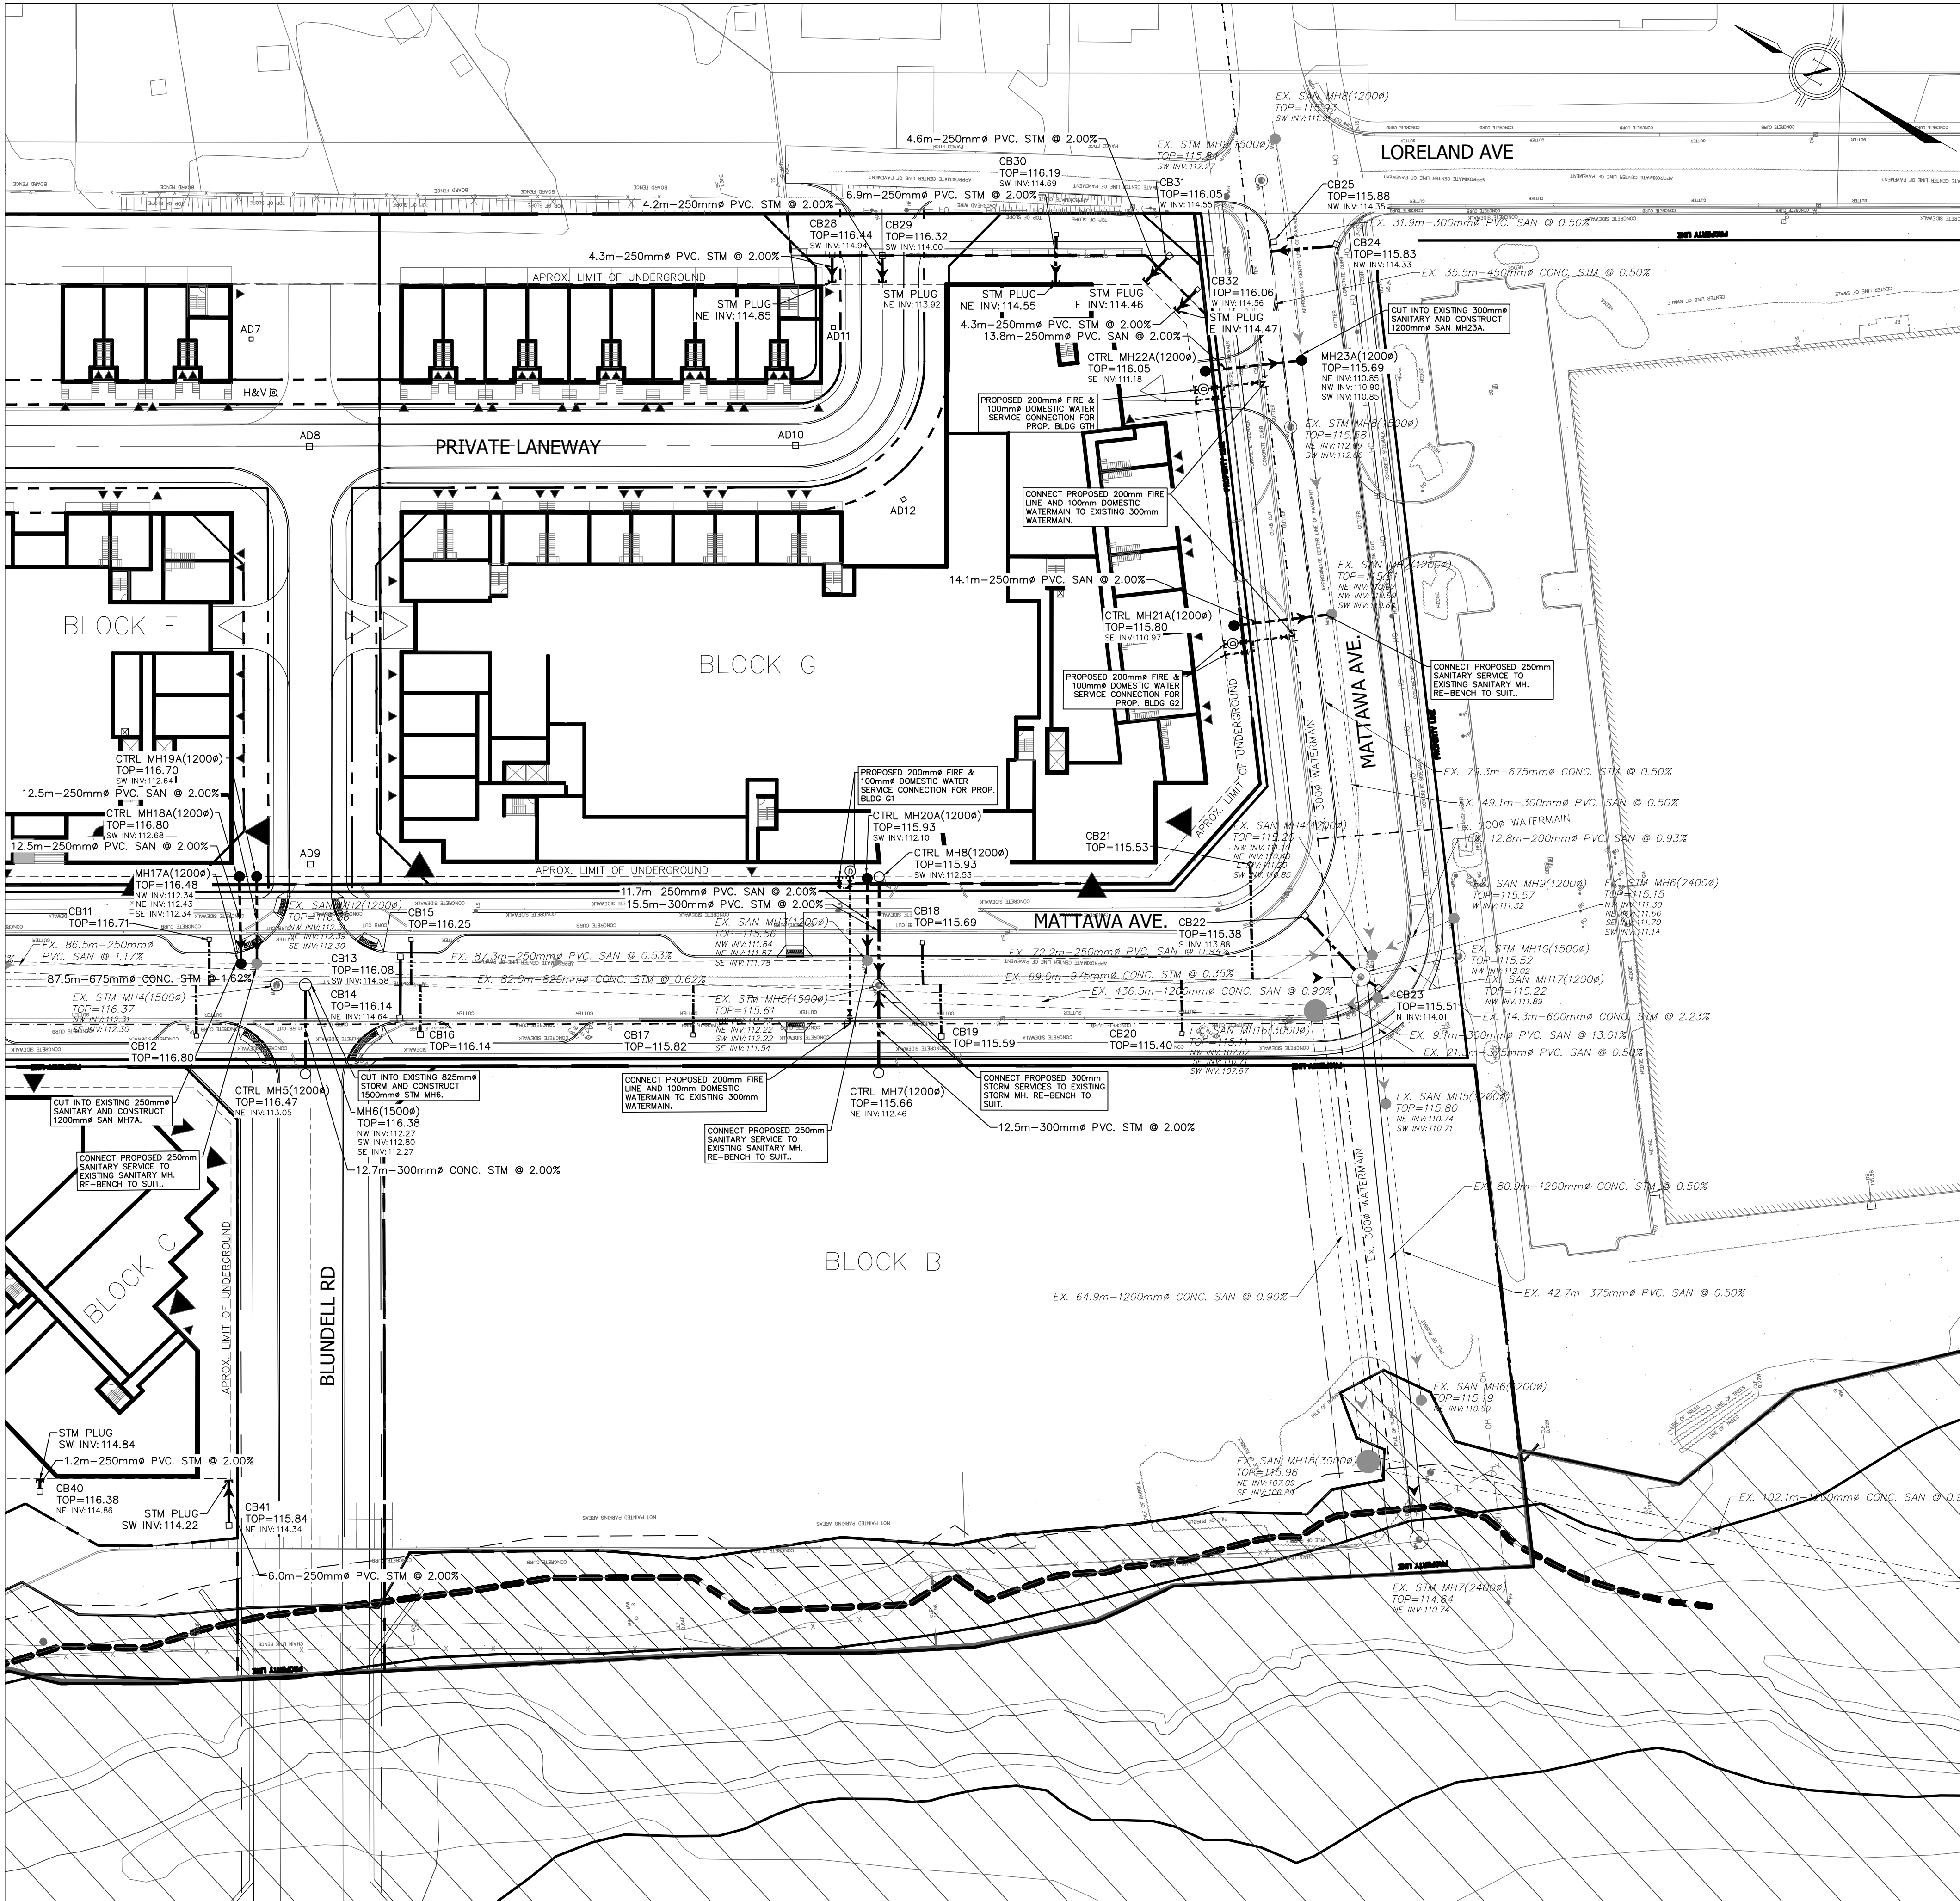


- NOTES:
1. ALL PROPOSED FIRE AND DOMESTIC WATERMAIN CONNECTIONS TO BE MADE WITH TAPPING SLEEVE WITH VALVE BOX AS PER REGION OF PEEL STANDARD 1-E-4.
 2. ALL PROPOSED WATERMAIN CONNECTIONS TO BE MADE AS PER REGION OF PEEL STANDARD 1-E-3.
 3. ALL DETECTOR CHECK VALVES TO BE INSTALLED IN CHAMBER AS PER REGION OF PEEL STANDARD 1-E-1.

BLDG	SAN Connection	STM Connection
BLDG A1	CTRL MH1A1	CTRL MH1
BLDG A2	CTRL MH3A	CTRL MH1
BLDG A3	CTRL MH5A	CTRL MH1
BLOCK B		CTRL MH7
BLDG C	CTRL MH15A	CTRL MH3
BLDG E1	CTRL MH8A	CTRL MH2
BLDG E2	CTRL MH10A	CTRL MH2
BLDG E3	CTRL MH12A	CTRL MH2
BLDG F1	CTRL MH14A	CTRL MH4
BLDG F3	CTRL MH16A	CTRL MH4
ETH-1	CTRL MH18A	CTRL MH4
ETH-2	CTRL MH19A	CTRL MH4
BLDG G1	CTRL MH20A	CTRL MH8
BLDG G2	CTRL MH21A	CTRL MH8
ETH	CTRL MH22A	CTRL MH8
Blundell Rd		CTRL MH5

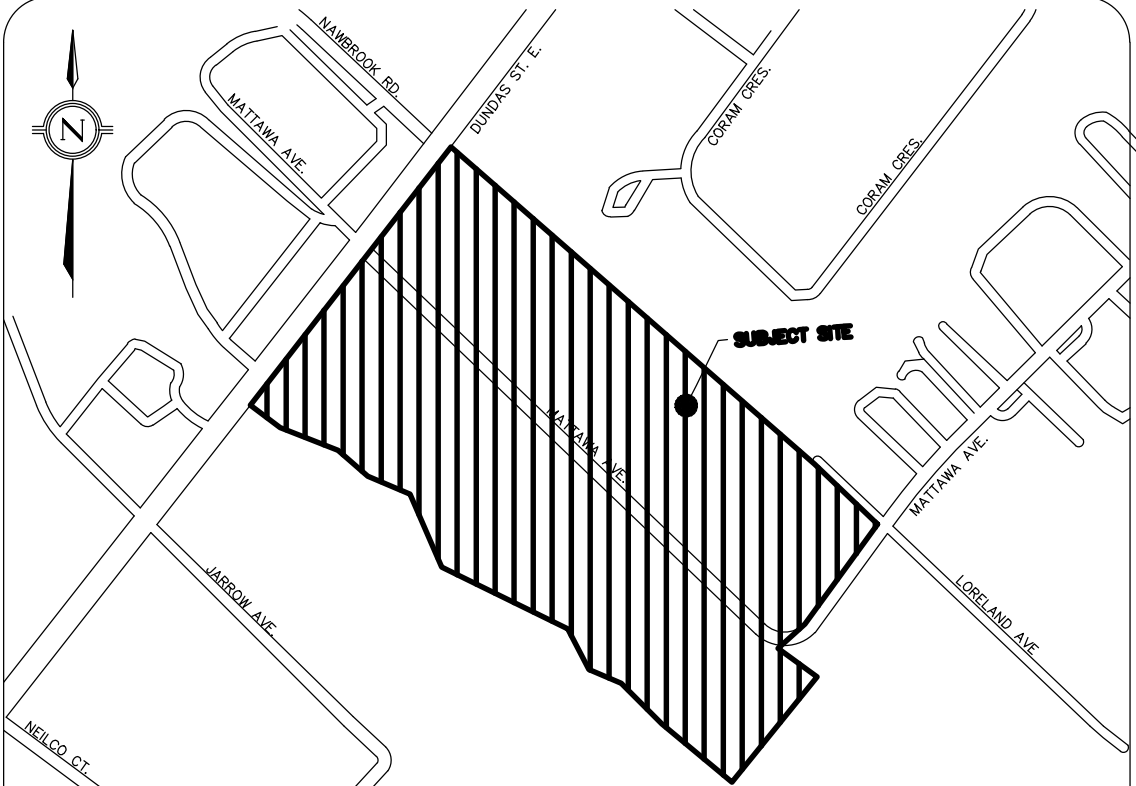

KEY PLAN

LEGEND

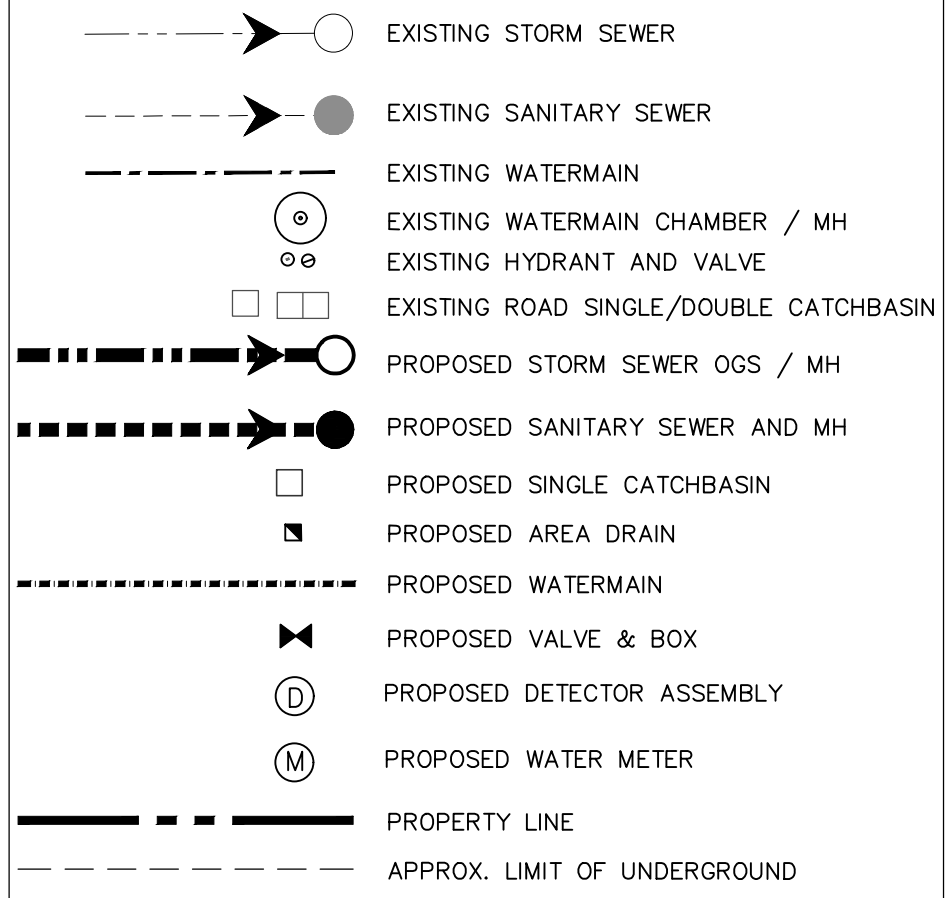

1. MEASUREMENTS IN METRES AND/OR MILLIMETRES UNLESS OTHERWISE SHOWN.
2. CONTRACTOR TO BE RESPONSIBLE FOR LOCATION OF ALL EXISTING UNDERGROUND & OVERHEAD UTILITIES. VARIOUS UTILITIES CONCERNED TO BE GIVEN REQUIRED ADVANCE NOTICE PRIOR TO ANY DIGGING FOR STAKE OUT. THE CONSULTANT ASSUMES NO RESPONSIBILITY FOR THE ACCURACY OF THE LOCATION OF EXISTING UTILITIES AS INDICATED ON THIS DRAWING.
3. THE INFORMATION CONTAINED ON THIS PLAN PERTAINS TO THE INSTALLATION OF NEW MUNICIPAL SERVING ONLY AND SHALL NOT BE RELIED UPON BY A THIRD PARTY FOR ANY OTHER DESIGN AND/OR CONSTRUCTION RELATED PURPOSES (INCLUDING PUBLIC & PRIVATE SERVING/UTILITY LOCATES, SHORING DESIGN AND FIELD LAYOUT, UTILITY DESIGN AND CONSTRUCTION, AND ALL OTHER DESIGN AND CONSTRUCTION RELATED ACTIVITIES). ALL THIRD PARTIES ARE RESPONSIBLE FOR OBTAINING THEIR OWN LOCATES FOR ANY PUBLICLY OR PRIVATELY HELD INFRASTRUCTURE WITHIN OR ADJACENT TO THE SUBJECT DEVELOPMENT.

1	ISSUED FOR OPA/ZBA #1	07/29/2022	K.L.
No.	REVISIONS/ISSUED	DATE	BY CITY

counterpoint 
ENGINEERING
COUNTERPOINT ENGINEERING INC.
8395 Jane St., Suite 100, Vaughan, ON L4K 5Y2 Phone 905-326-1404 Fax 905-326-1405



APPLICANT:
HAZELVIEW INVESTMENTS
1133 YONGE STREET, 4TH FLOOR
TORONTO, ON M4T 1W1
PHONE: 1-888-949-8439

CONTACT: DEREK WEI - dwei@hazelview.com

SITE LOCATION:
RESIDENTIAL/COMMERCIAL DEVELOPMENT
DUNDAS & MATTAWA
1580-1590 & 1650 DUNDAS STREET EAST
MISSISSAUGA, ON
SITE PLAN FILE No.:

SITE SERVICING PLAN

DESIGNED BY:	K.L.	CHECKED BY:	D.L.	DATE:	SEPT 2021
DRAWING BY:	K.L.	CHECKED BY:	D.L.	PROJECT NO.	20129
SWM BY:	K.L.	CHECKED BY:	D.L.	DRAWING NO.	SP-2
SCALE:	0m 5m 10m 20m 30m				
1:500m					