




NOTE:
CONTRACTOR MUST CHECK AND VERIFY ALL
DIMENSIONS AND BE RESPONSIBLE FOR SAME.
REPORTING ANY DISCREPANCIES TO THE OWNER,
BEFORE TENDER CLOSING.
LATEST APPROVED DRAWINGS ONLY TO BE USED FOR
CONSTRUCTION.
PRINTS ARE NOT TO BE SCALED.

ISSUED	
DATE	DESCRIPTION
12/12/2024	ISSUED FOR OPA, ZBA & DPSS SUBMISSION

NO.	DATE	DESCRIPTION	DRAWN	CHECKED

Lam & Associates Ltd.
Mechanical/Electrical Engineers
100 Industrial Court, Unit 20, Concord, Ont., Canada L4K 4M1
Tel: (905) 880-7678

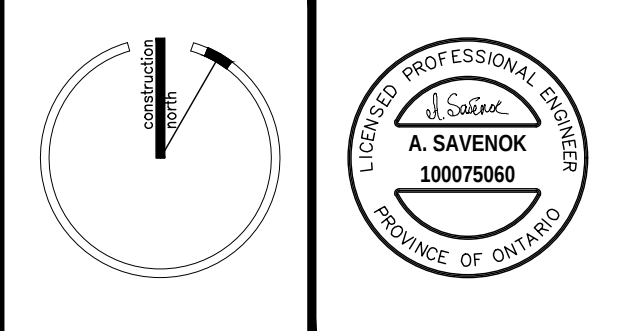

PROJECT
1995 DUNDAS ST E,
MISSISSAUGA

TITLE
14-16TH FLOOR PLAN –
OVERALL PLAN (ALL 2 PHASES)
MECHANICAL & ELECTRICAL

DATE: DECEMBER, 2024	
DRAWN BY: A.S.	CHECKED BY: P.L.
SCALE: 1:150	DWG. NO. ME-2.10
JOB NO: 24-05	