


**LEGAL DESCRIPTION**

FOR LEGAL SURVEY INFORMATION REFER TO:  
 PART OF LOT 14  
 CONCESSION 10, NEW SURVEY  
 GEOGRAPHIC TOWNSHIP OF TRAFALGAR  
 CITY OF MISSISSAUGA  
 REGIONAL MUNICIPALITY OF PEEL  
 PREPARED BY GENESIS LAND SURVEYING INC.,  
 10 FOUR SEASONS PLACE, 10TH FLOOR,  
 TORONTO, ON M9B 6H7 DATED OCTOBER 16, 2024.

SITE SPECIFIC ZONING TO BE VERIFIED UPON  
 CONSULTATION WITH CITY OF MISSISSAUGA. LAYOUT  
 IS SUBJECT TO IMPLEMENTATION OF ENVIRONMENTAL,  
 STORM WATER MANAGEMENT, ETC. REQUIREMENTS  
 UPON CONSULTATION WITH AUTHORITIES HAVING  
 JURISDICTION

**ADDITIONAL SITE WORKS**

NOTE:  
 FOR LANDSCAPE AND SITE FURNITURE INFORMATION,  
 REFER TO DRAWINGS BY MIBC.  
 FOR GRADING AND SERVICING INFORMATION, REFER  
 TO DRAWINGS BY MTE.  
 FOR ELECTRICAL INFORMATION, REFER TO DRAWINGS  
 BY HAMMERSCHLAG & JOFFE.  
 FOR TRAFFIC SIGNAGE AND DESIGN REFER TO  
 DRAWINGS BY TYLIN.

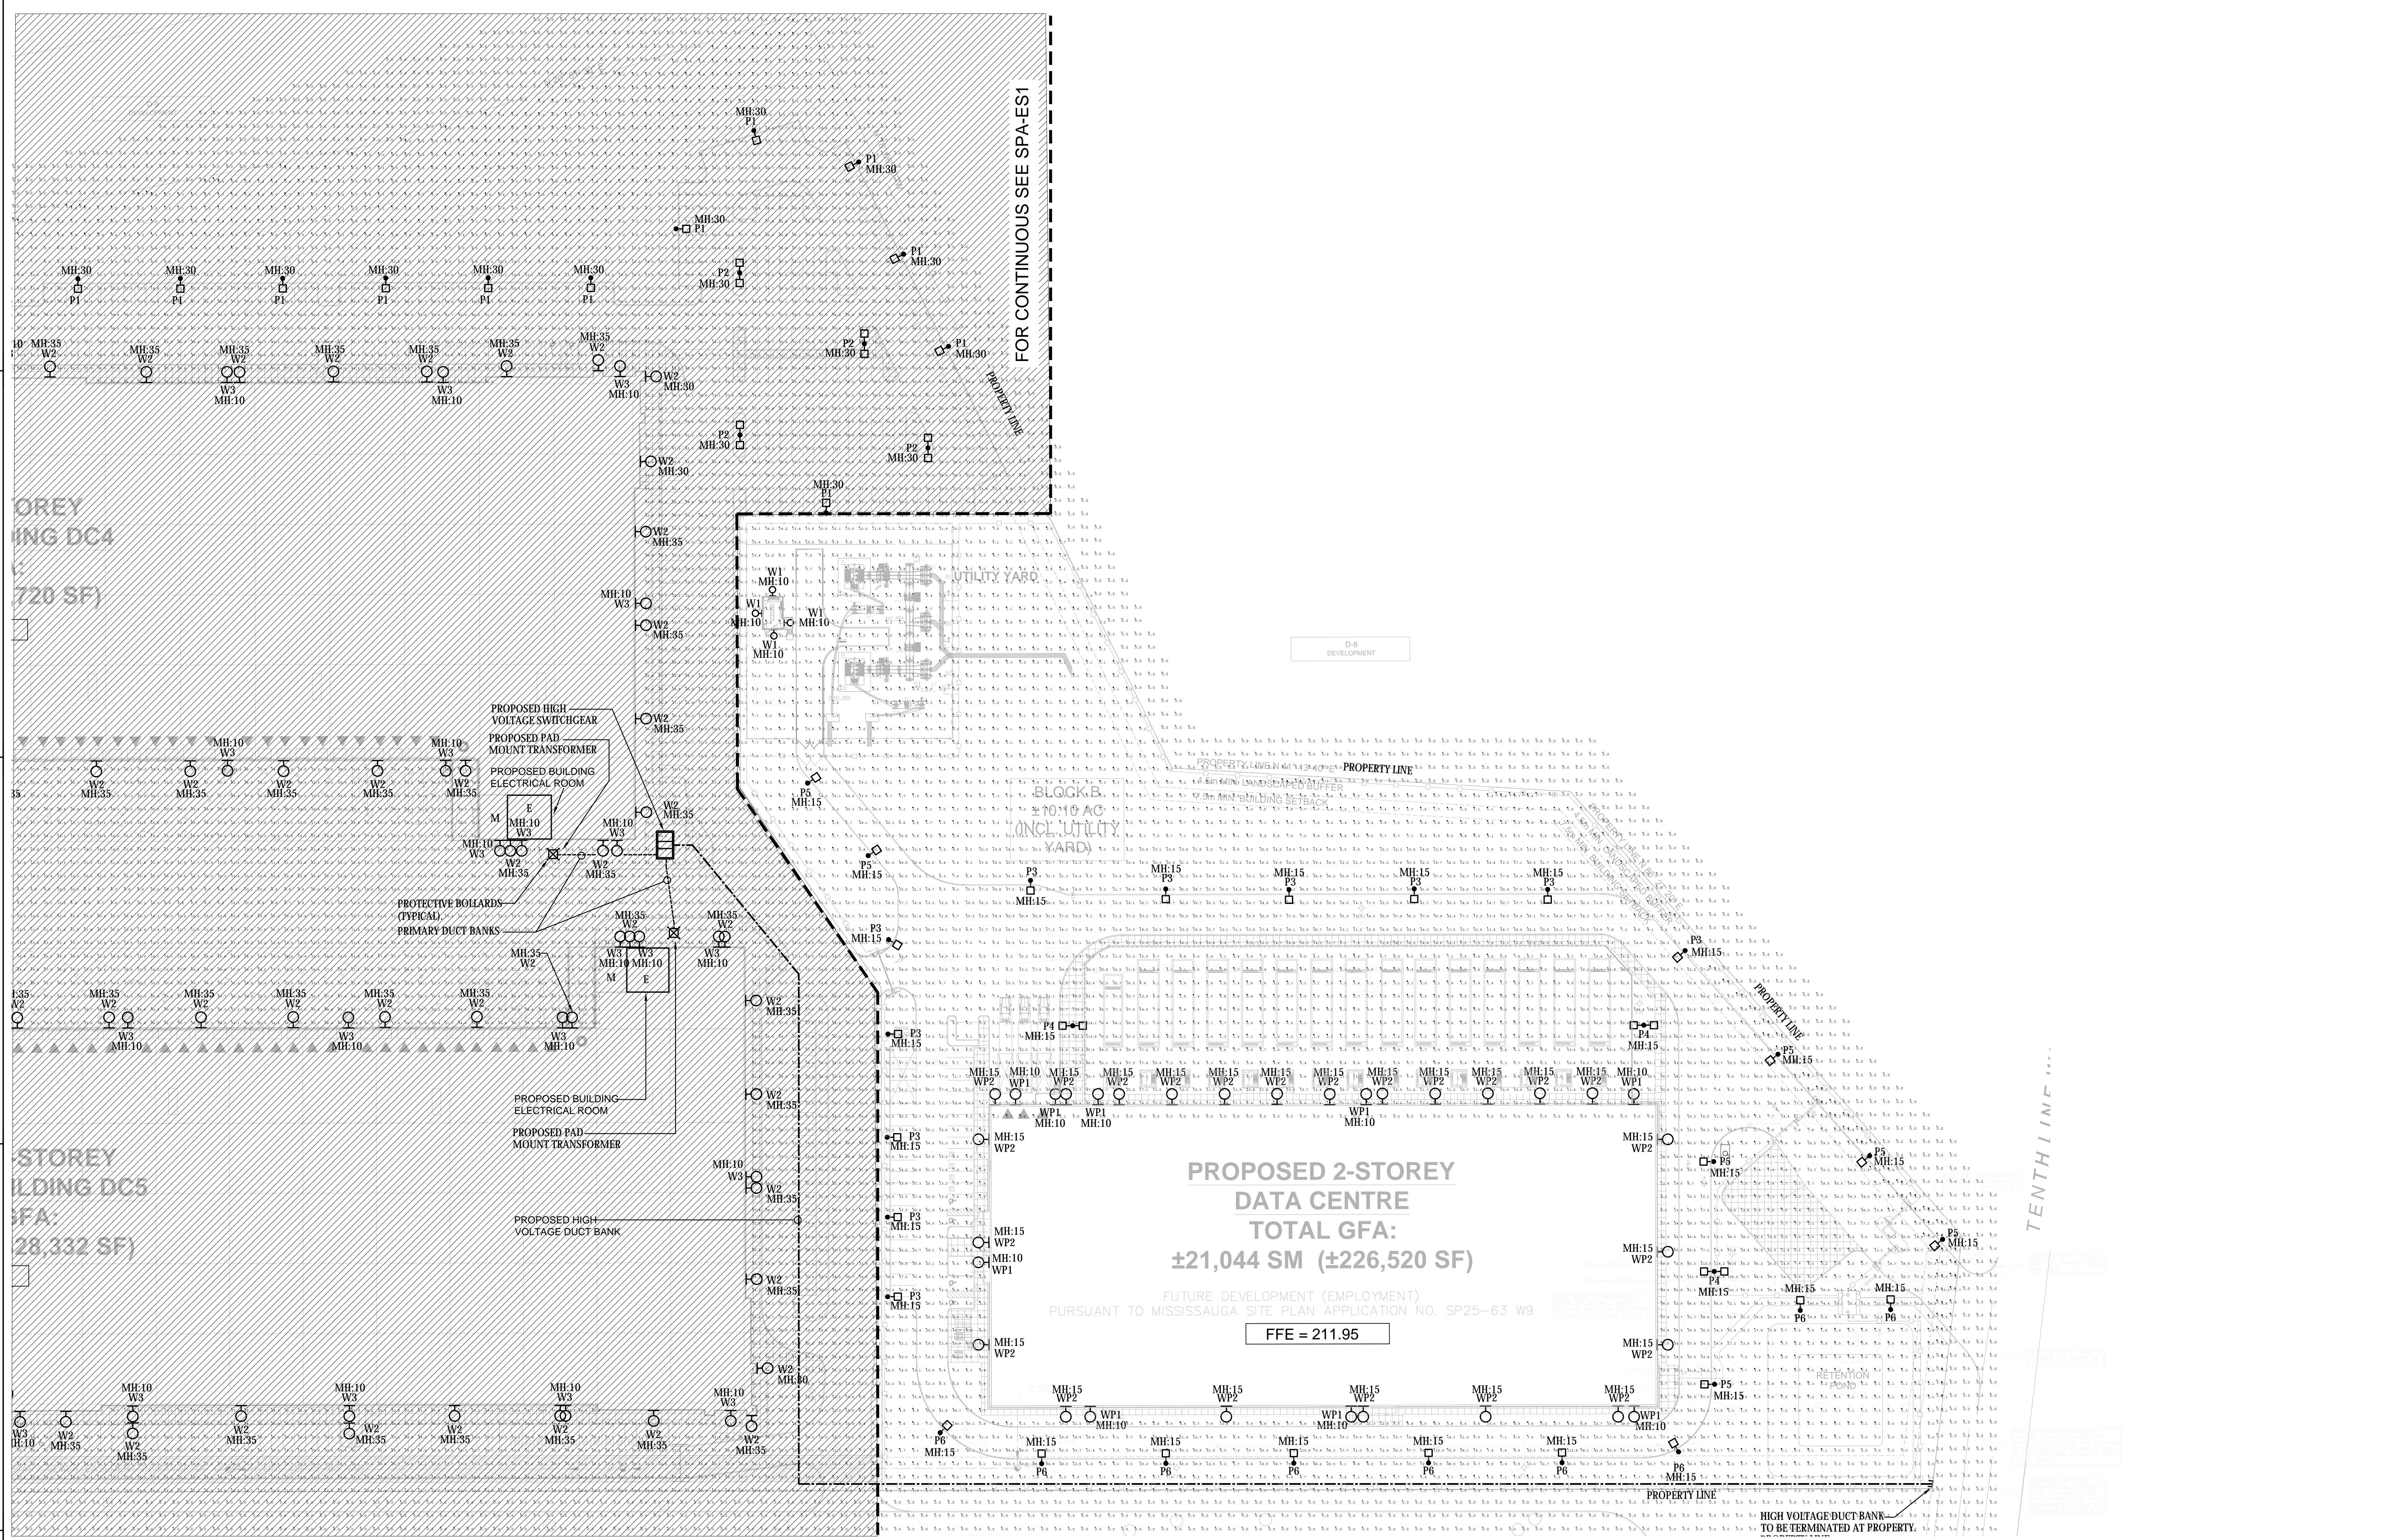

**PROPOSED 2-STOREY  
 DATA CENTRE  
 TOTAL GFA:  
 ±21,044 SM (±226,520 SF)**

FUTURE DEVELOPMENT (EMPLOYMENT)  
 PURSUANT TO MISSISSAUGA SITE PLAN APPLICATION NO. SP25-63 W9  
**FFE = 211.95**

**1** PROPOSED 2 STOREY DATA CENTRE - PHOTOMETRIC  
 Scale 1 : 600

ALL LIGHTING FIXTURES ARE DARK-SKY  
 COMPLIANT (FULL CUT OFF FIXTURES).

Label	CalcType	Units	Avg	Max	Min	Avg/Min	Max/Min
CALC AREA	Illuminance	Lux	16.01	153	0	N.A.	N.A.
PROPERTY LINE	Illuminance	Lux	0.0	0.0	0.0	N.A.	N.A.
PARKING LOT	Illuminance	Lux	24.77	52	4	6.19	13.00
GENERATOR YARD	Illuminance	Lux	11.87	114	0	N.A.	N.A.
UTILITY YARD	Illuminance	Lux	4.97	29	0	N.A.	N.A.

Symbol	Qty	Label	Arrangement	ILF	Description	Lum. Watts	LUG RATING
	10	P3	SINGLE	0.9	DISTRIBUTION PACKAGE 4000K CCT TYPE R5 RSX AREA FIXTURE SIZE 2 P4 LUMEN LITHONIA CAT.#RSX2 LED P2 40K R5	114.07	B5-U0-G3
	3	P4	2 @ 180 DEGREES	0.9	DISTRIBUTION PACKAGE 4000K CCT TYPE R5 RSX AREA FIXTURE SIZE 2 P2 LUMEN LITHONIA CAT.#RSX2 LED P4 40K R5	379.08	B5-U0-G4
	9	P5	SINGLE	0.9	DISTRIBUTION WITH HS SHIELD RSX LED AREA LUMINAIRE SIZE 2 P1 LUMEN PACKAGE 4000K CCT TYPE R3 LITHONIA CAT.#HS RSX2 LED P1 40K R3	72.06	B1-U0-G2
	9	P6	SINGLE	0.9	DISTRIBUTION WITH HS SHIELD RSX LED AREA LUMINAIRE SIZE 2 P1 LUMEN PACKAGE 4000K CCT TYPE R2 LITHONIA CAT.# HS RSX2 LED P1 40K R2	72.06	B1-U0-G1
	12	WP1	SINGLE	0.9	MEDIUM OPTIC PACKAGE 4000K 80CRI TYPE 4 WDGE2 LED WITH P2 - PERFORMANCE LITHONIA CAT.#80CR1T4M WDGE2 LED P2 40K	18.9815	B1-U0-G1
	23	WP2	SINGLE	0.9	PACKAGE 4000K 80CRI TYPE WDGE2 LED WITH P4 - PERFORMANCE FORWARD THROW MEDIUM OPTIC LITHONIA CAT.#80CR1FT4M WDGE2 LED P4 40K	46.6589	B1-U0-G1

REV #	DATE	REVISION TITLE
03	2026-03-04	ISSUED FOR SPA RE-SUBMISSION
02	2025-08-15	ISSUED FOR SPA
01	2025-08-01	ISSUED FOR REVIEW

**7564 TENTH LINE WEST**  
 7564-10th LINE W.  
 MISSISSAUGA, ONTARIO

Prologis Inc. (Canada)  
 185 The West Mall, Suite 700, Toronto  
 647-258-2600



**PROPOSED 2-STOREY DATA  
 CENTRE LIGHTING  
 PHOTOMETRIC**

SEAL: SHEET NO. **SPA-ES2**