
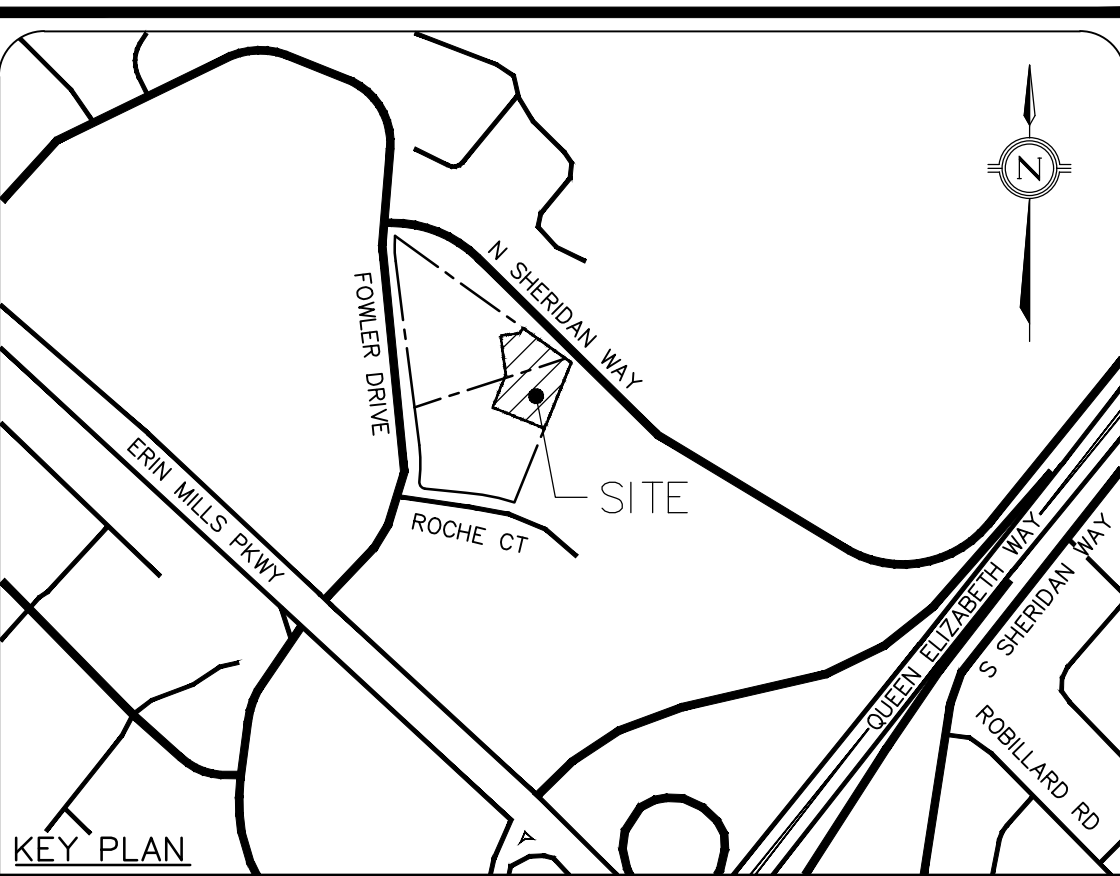


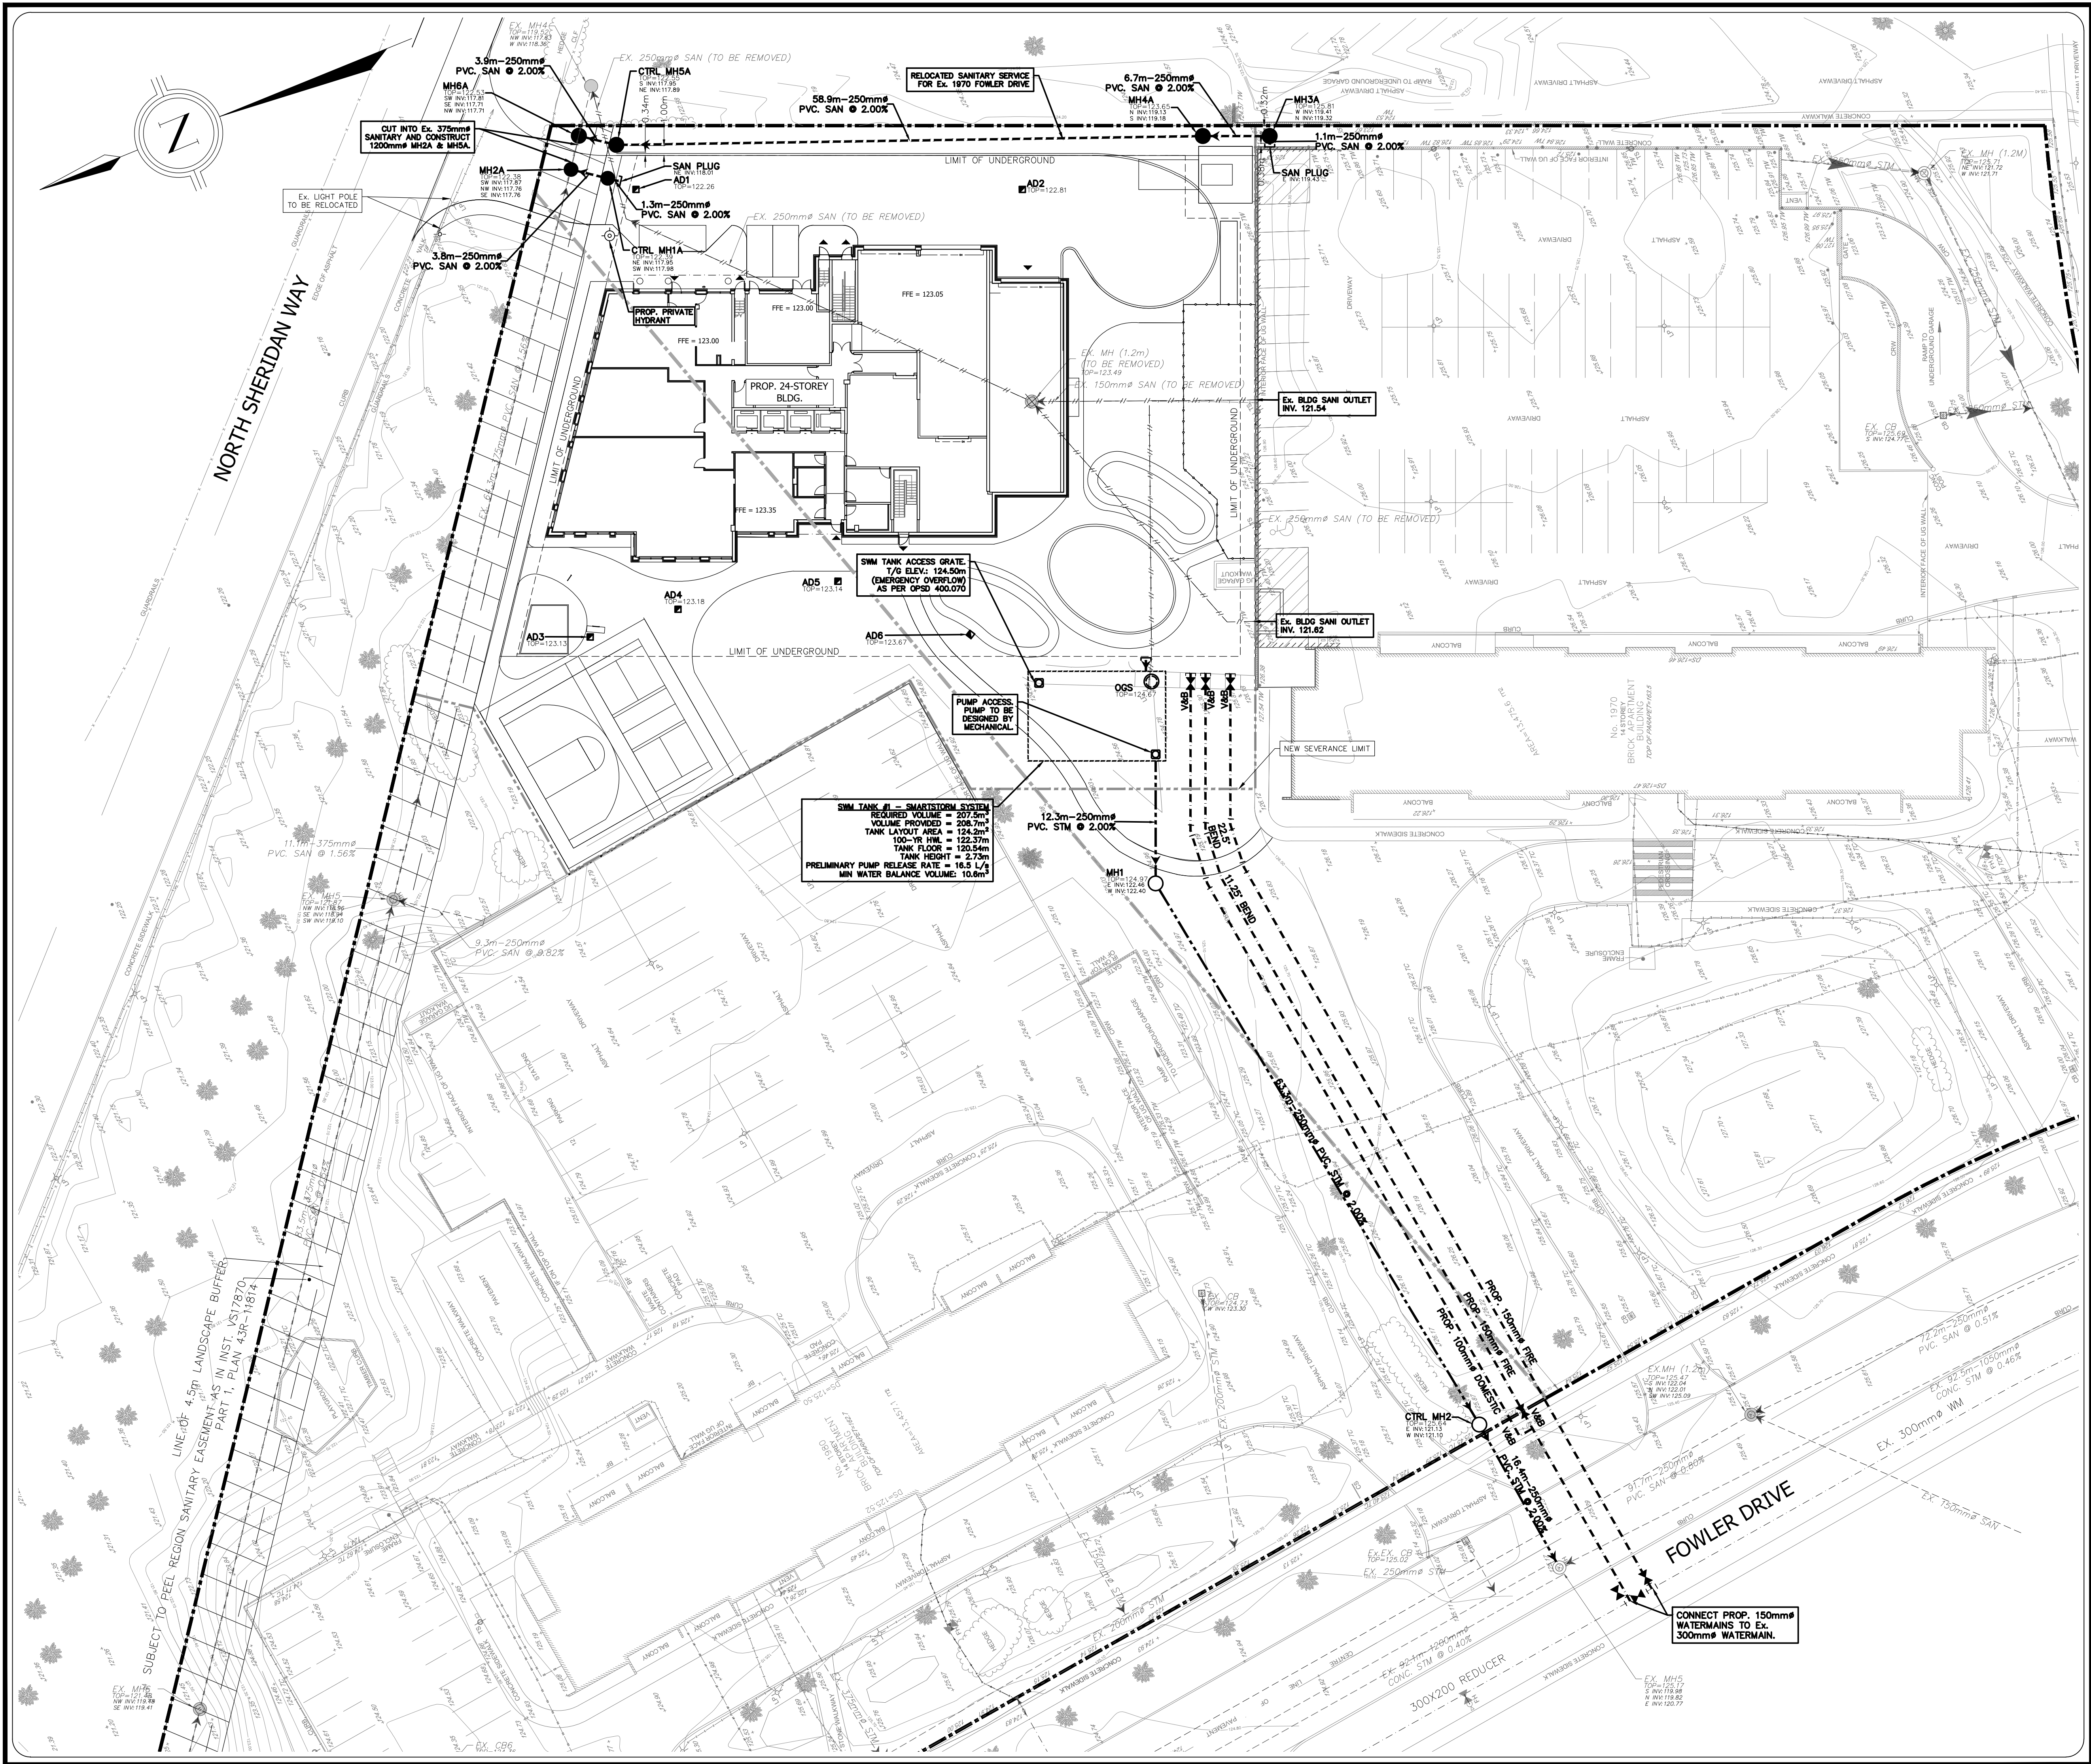

- LEGEND
- PROPERTY LINE
 - EXISTING WATERMAIN
 - EXISTING VALVE CHAMBER
 - EXISTING HYDRANT
 - EXISTING STORM SEWER AND MH
 - EXISTING CATCHBASIN
 - EXISTING MANHOLE
 - EXISTING SANITARY SEWER AND MH
 - PROPOSED WATERMAIN
 - PROPOSED VALVE AND BOX
 - PROPOSED HYDRANT
 - PROPOSED WATERMAIN PLUG
 - PROPOSED STORM SEWER AND MH
 - PROPOSED CATCHBASIN
 - PROPOSED STORM PLUG
 - PROPOSED SANITARY SEWER AND MH
 - PROPOSED SANITARY PLUG
 - LINEAR REMOVALS

LEGAL & TOPOGRAPHY
PROVIDED BY: AKSAN PILLER CORPORATION LTD.
943 MT PLEASANT ROAD
TORONTO, ON M4P 2L7
PHONE: (416) 488-7843

BENCHMARK AND ELEVATION
ELEVATIONS SHOWN HEREON ARE GEODETIC AND ARE DERIVED FROM THE CITY OF MISSISSAUGA BENCHMARK NO. 478 LOCATED ON THE SOUTH FACE AT THE CENTRE OF GREY BRICK AND CONCRETE BLOCK BUILDING NO.1801, ON THE NORTH SIDE OF THE NORTH SIDE OF NORTH SHERIDAN WAY, 152m WEST OF ROBIN DRIVE, ELEVATION 112.471m. BEARINGS ARE UTM GRID, DERIVED FROM GNSS OBSERVATIONS, USING A REAL TIME KINEMATIC SERVICE, ON MONUMENTS 1 & 2, SHOWN HEREON, HAVING A BEARING OF N06°46'10"W, AND ARE REFERRED TO THE CENTRAL MERIDIAN OF UTM ZONE 17 (81°00' WEST LONGITUDE) NAD83 (CSRS) (2010).

No.	REVISIONS/ISSUED	DATE	BY	CITY
3	ISSUED FOR OPA / ZBA RESUBMISSION #2	07/10/2026	KL	
2	ISSUED FOR OPA / ZBA RESUBMISSION #2	04/17/2026	KL	
1	ISSUED FOR 1ST OPA/ZBA SUBMISSION	11/21/2025	KL	

counterpoint ENGINEERING

A SUBSIDIARY OF DILLON CONSULTING LIMITED

8395 Jane St., Suite 100, Vaughan, ON L4K 5Y2 Phone 905.326.1404 Fax 905.326.1405

LICENSED PROFESSIONAL ENGINEER

K.L.Y.

100190179

JUL 10, 2026

PROVINCE OF ONTARIO

ENGINEER'S STAMP

APPLICANT:
IMH 1970 & 1980 FOWLER DRIVE LTD.
1400-3280 BLOOR STREET EAST, CENTRE TOWER
TORONTO, ON M8X 2X3
PHONE: 416-234-8444
FAX:
CONTACT:

SITE LOCATION:
RESIDENTIAL DEVELOPMENT
1970-1980 FOWLER DRIVE
MISSISSAUGA, ON

SITE PLAN FILE No.:

SITE SERVICING CONCEPT		
DESIGNED BY: B.N.	CHECKED BY: K.L.	DATE: JUNE 2025
DRAWING BY: B.N.	CHECKED BY: K.L.	PROJECT NO. 23039
SCALE: 0m 10m 20m	CHECKED BY: K.L.	DRAWING NO. SW-S
1: 300m		